


PLAN 1
 0 1000 2000 3000 mm SCALE 1:100
 DEMOLITION

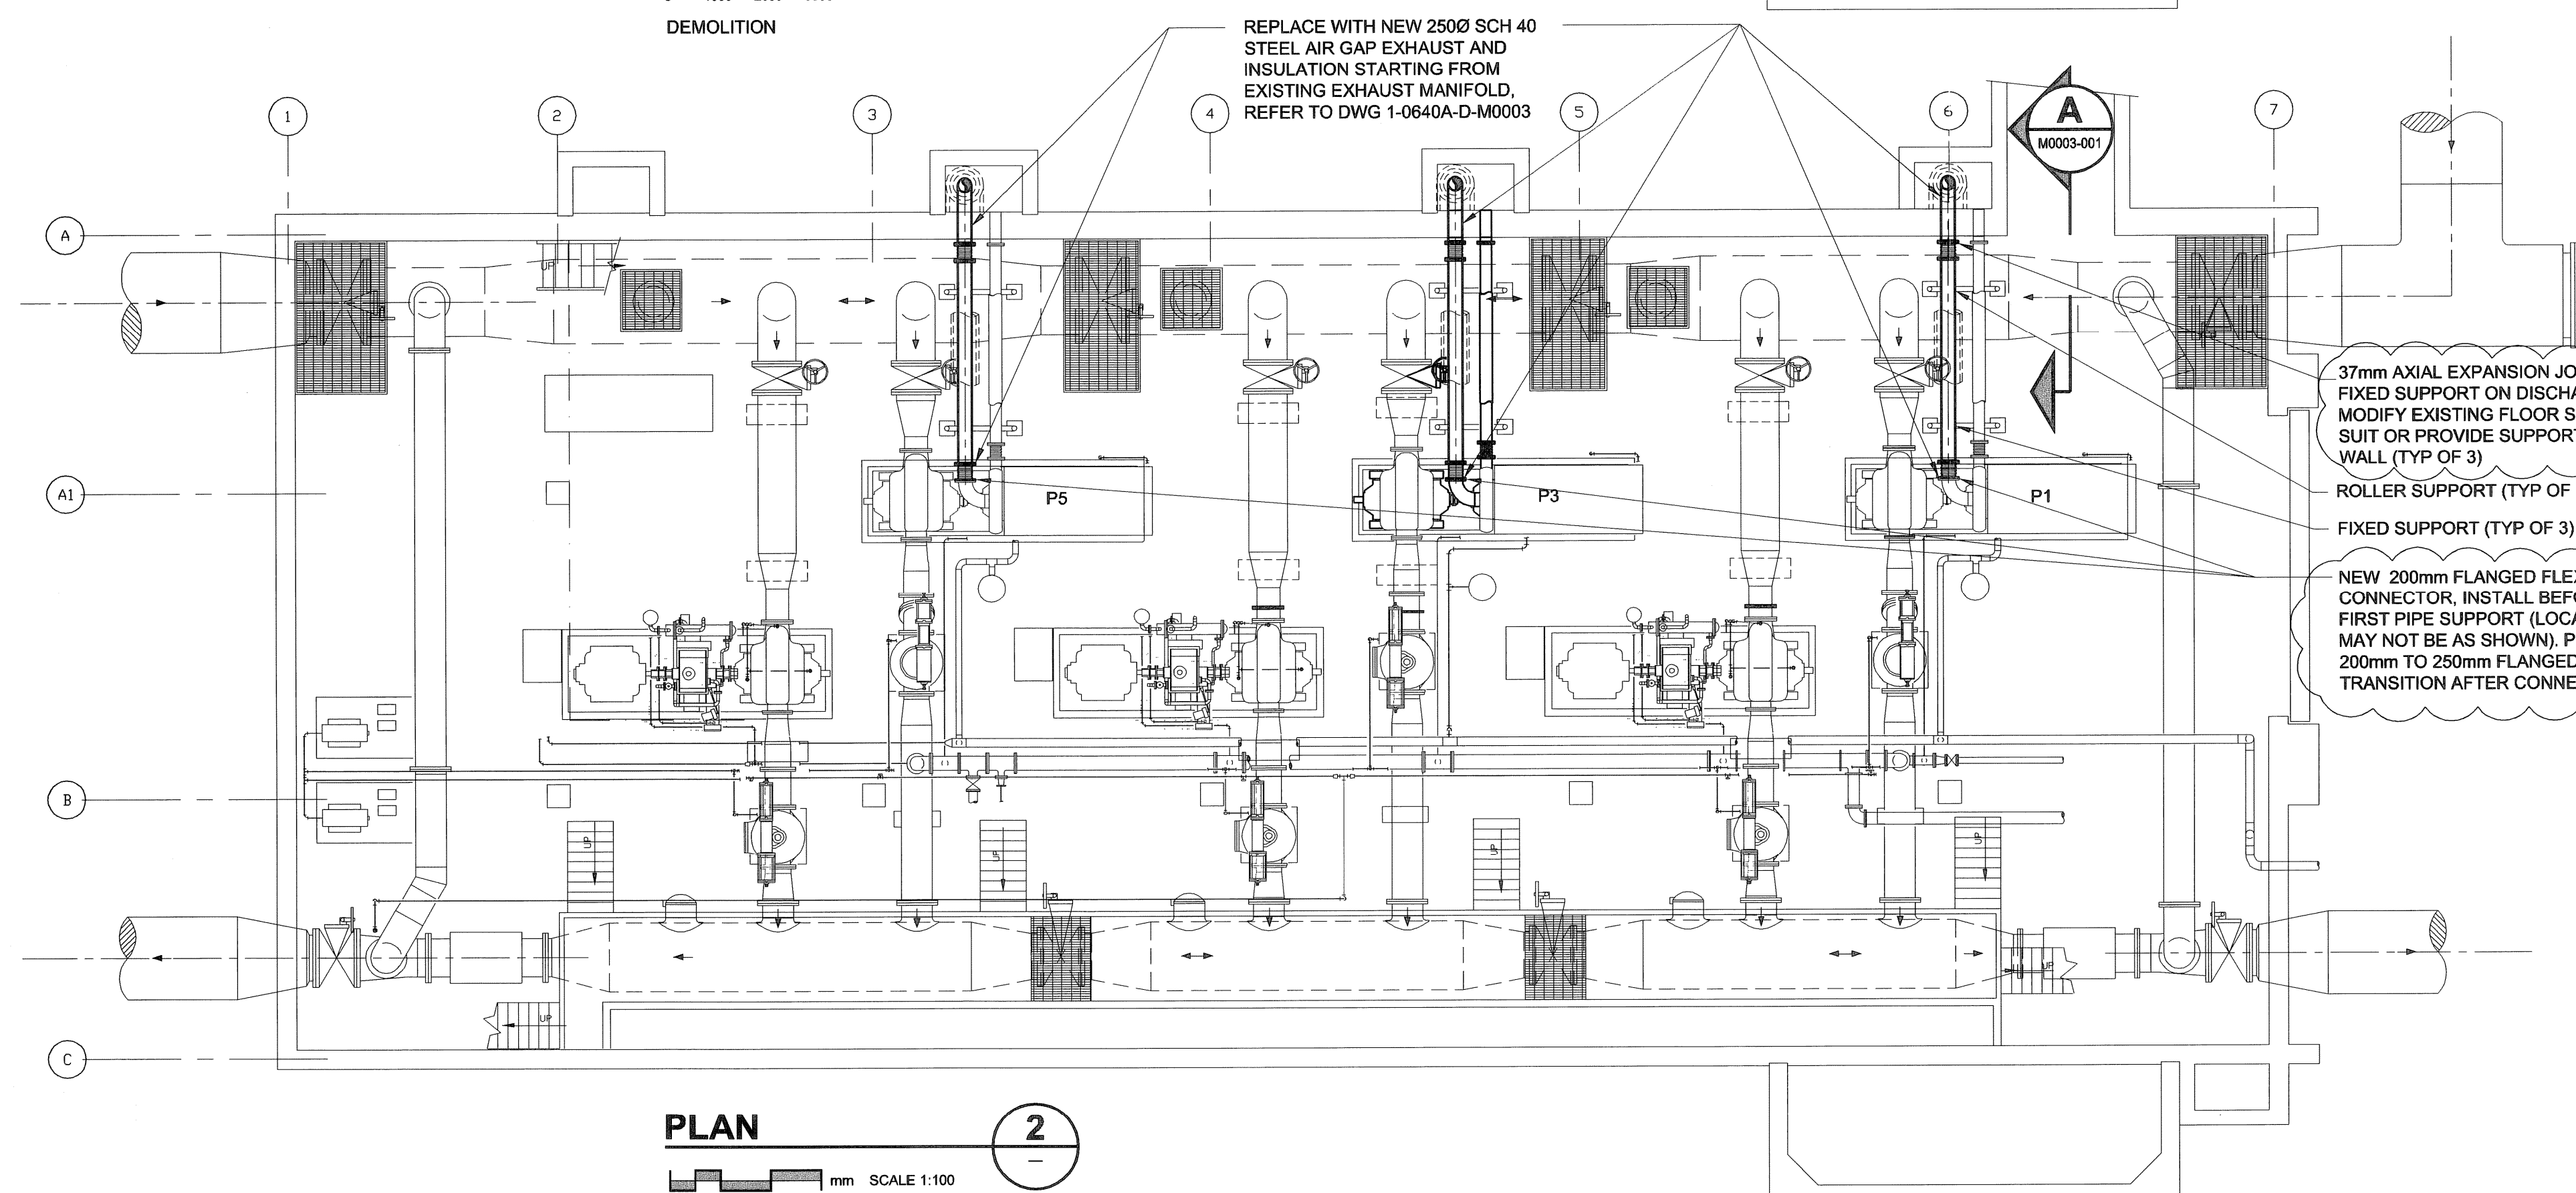

PLAN 2
 0 1000 2000 3000 mm SCALE 1:100
 NEW CONSTRUCTION

APEGM
 Certificate of Authorization
 UMA Engineering Ltd. (MB)
 No. 256 Date: Dec 10-08

DRN	CHK	DES	ENG	IDR
RL	AS	CC	CC	Ø
UMA REVIEW				

NO.	REVISIONS	DATE	BY
D	ISSUED FOR ADDENDUM	03/12/10	RS
C	ISSUED FOR BID	03/11/21	RS
B	ISSUED FOR REVIEW	03/10/28	RS
A	ISSUED FOR REVIEW	08/09/29	RS

UMA AECOM	
DESIGNED BY	CC
DRAWN BY	RS
HOR. SCALE	AS NOTED
VERT. SCALE	AS NOTED
DATE	

© 2008 UMA Engineering Ltd. All Rights Reserved. This document is protected by copyright law and may not be used, reproduced or modified in any manner or for any purpose except with the written permission of UMA Engineering Ltd. or a party to which its copyright has been assigned. UMA accepts no responsibility and denies any liability whatsoever, to any party that uses, reproduces, modifies, or relies on this document without UMA's express written consent.

PROFESSIONAL'S SEAL
 PROVINCE OF MANITOBA
 Dec 10-08
 C.A.D.
 COURCHAINE
 REGISTERED PROFESSIONAL ENGINEER
 CONSULTANT DRAWING NO.
 D265-199-00_04-M-0002_RX.dwg

THE CITY OF WINNIPEG
WATER AND WASTE DEPARTMENT

MCPHILLIPS PUMPING STATION
P1, 3, 5 EXHAUST REPLACEMENT
MECHANICAL - DEMOLITION/NEW CONSTRUCTION
PUMP/ENGINE LEVEL FLOOR PLAN

SHEET 1 OF 1
 CITY DRAWING NUMBER
 1-0640M-M0002-001
 REV D