


| LEGEND |                                     |
|--------|-------------------------------------|
| RGS    | RIGID GALVANIZED STEEL CONDUIT      |
| LFMC   | LIQUID TIGHT FLEXIBLE METAL CONDUIT |

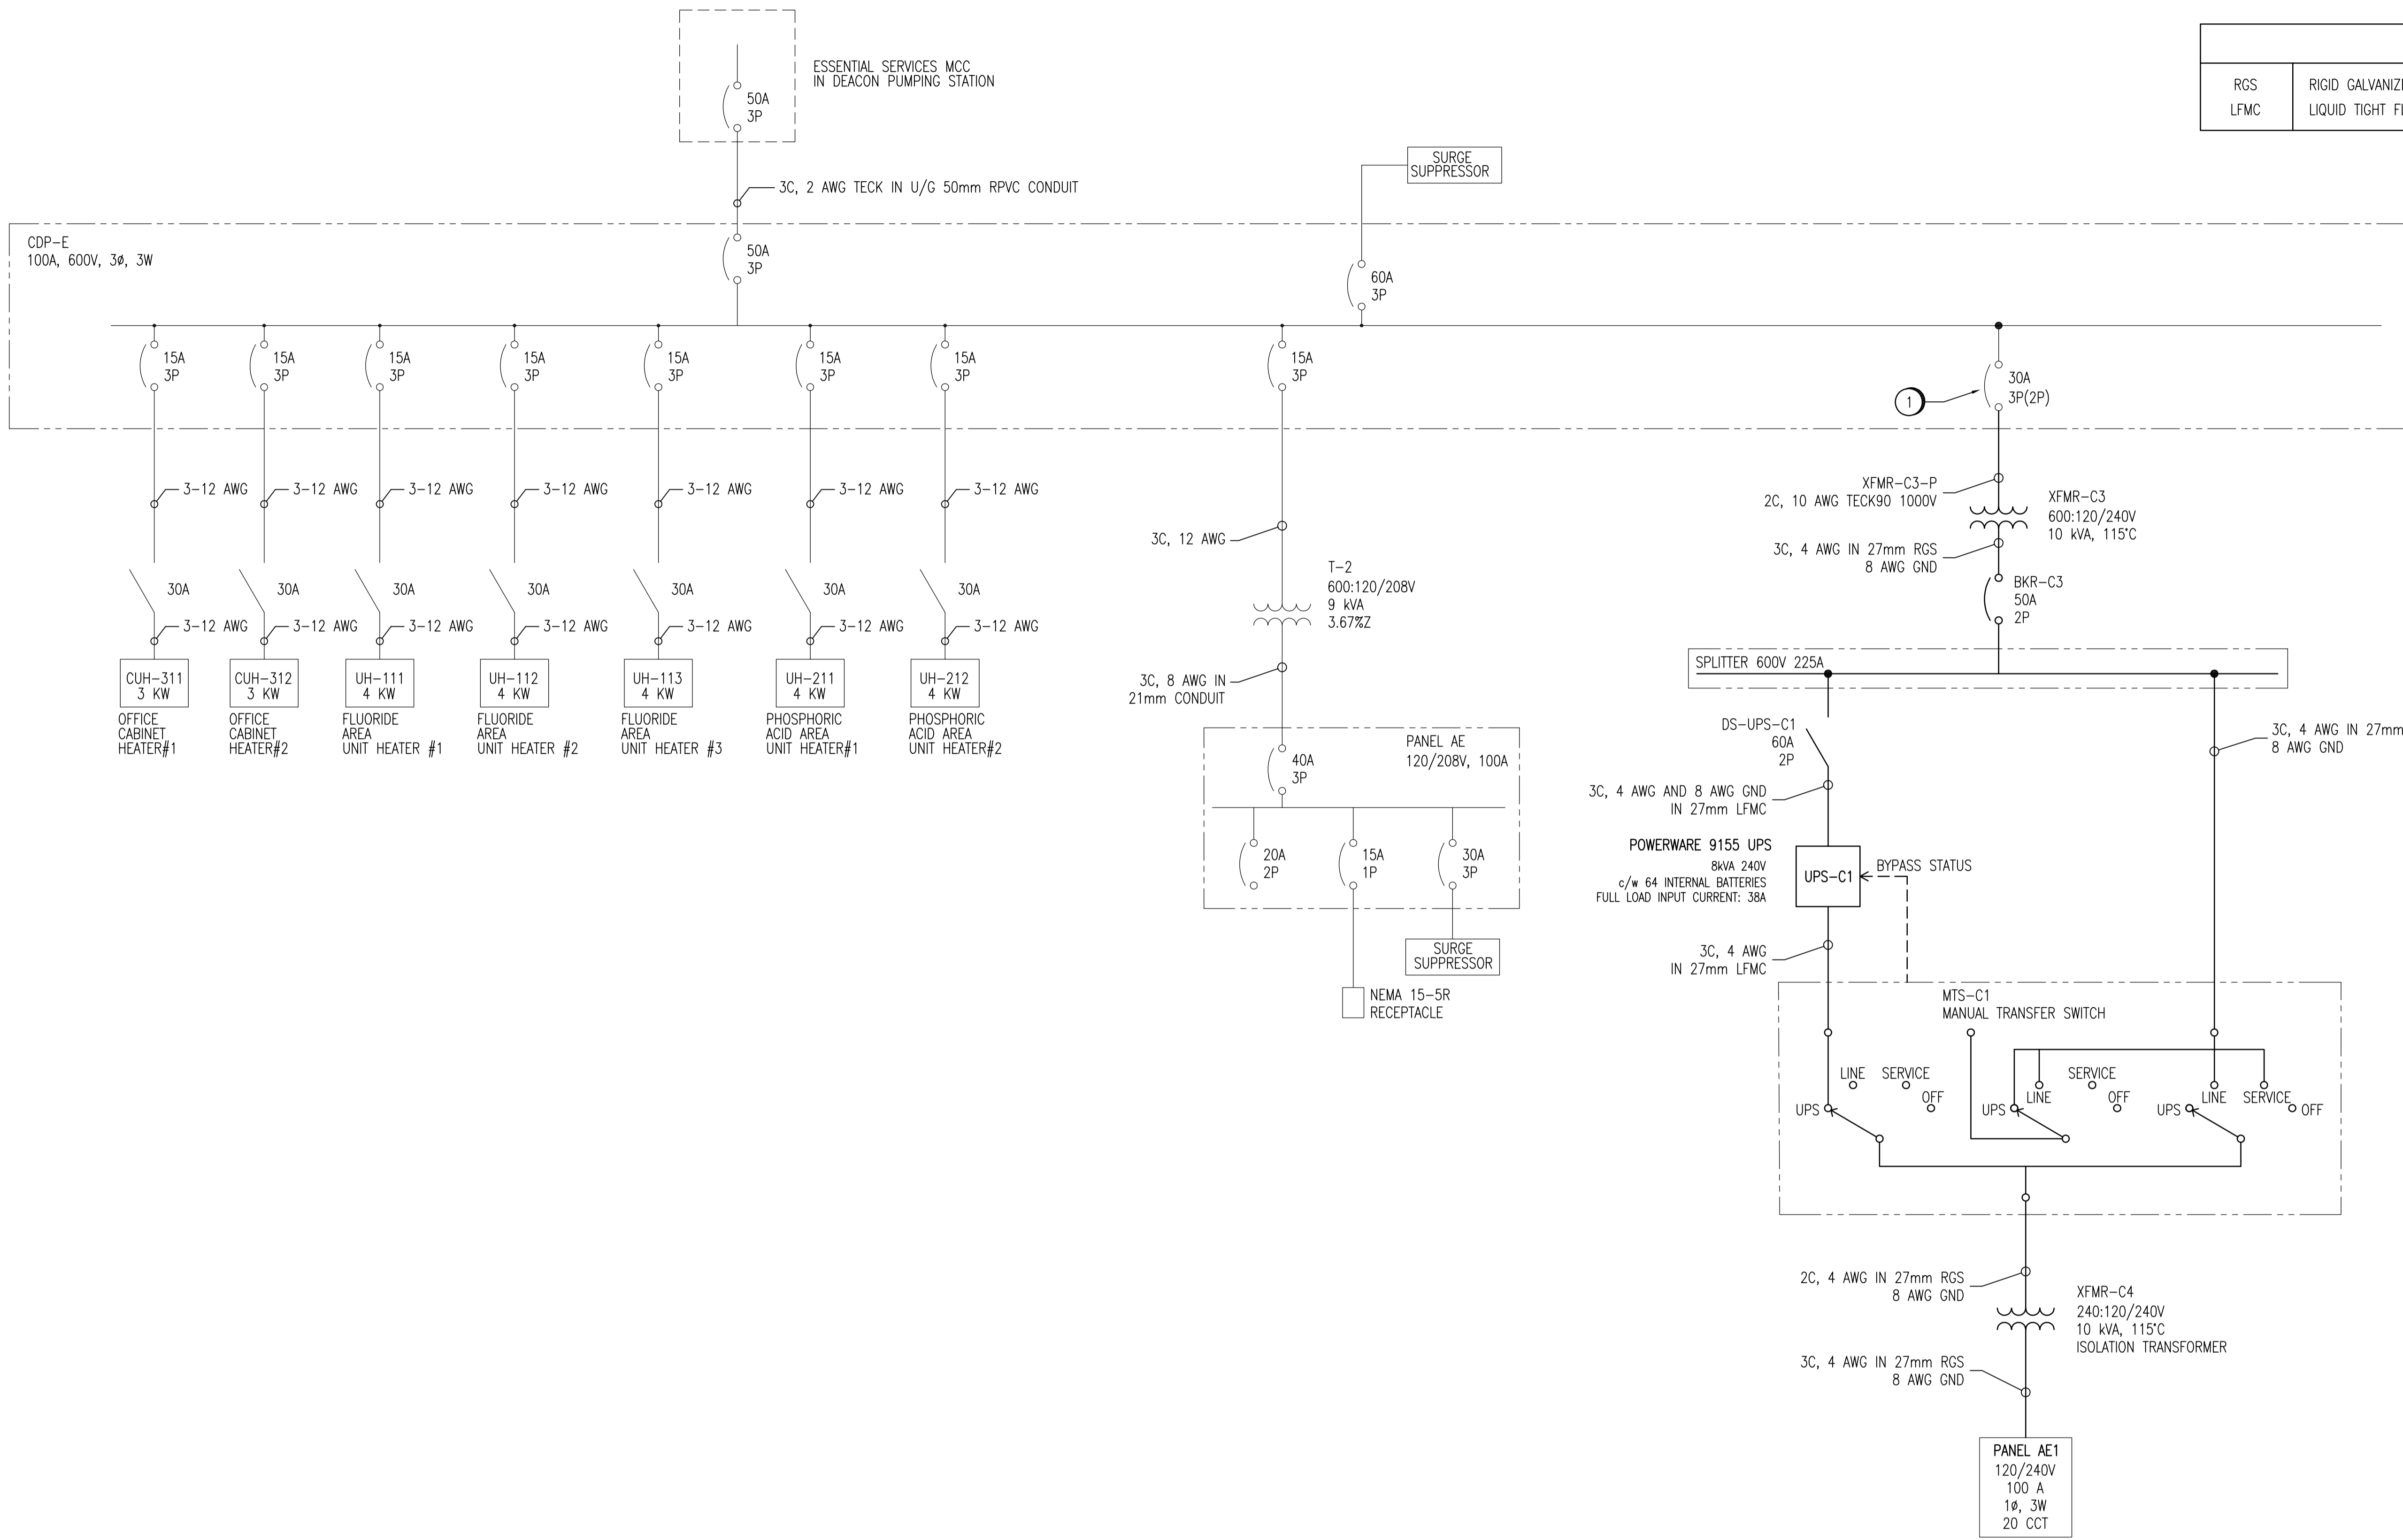

| NO. | CONSTRUCTION NOTES   |
|-----|--|
| 1   | UTILIZE EXISTING 30A SPARE BREAKER, LABEL AS "XFMR-C3 (UPS-C1)".<br>PROVIDE AN UPDATED TYPEWRITTEN PANEL DIRECTORY AND INSTALL A LAMICOID<br>ADJACENT TO (RIGHT OF) THE BREAKER. |

NOTES:  
 1. THIS DRAWING SUPERCEDES PART OF DRAWING D-5735.



|                       |                           |
|-----------------------|---------------------------|
| B.M. ELEV.            | FIELD BOOK #:             |
| POSTED TO LBIS        |                           |
| DESIGNED BY C. REIMER | CHECKED BY C. REIMER      |
| DRAWN BY A. OLIVER    | APPROVED BY C. REIMER     |
| HOR. SCALE NTS        | RELEASED FOR CONSTRUCTION |
| VERTICAL NTS          | DATE                      |
| 00 ISSUED FOR TENDER  | 2008/01/08 AEO            |
| NO. REVISIONS         | DATE BY                   |

**SNC-LAVALIN INC.**  
 148 Nature Park Way  
 Winnipeg, MB, Canada R3P 0X7  
 204-786-8080

DATE: 2007/07/05

FILENAME: 1-0620C-E0002-001-00.dwg

ENGINEER'S SEAL  
**PRELIMINARY**  
**NOT TO BE USED FOR CONSTRUCTION**

**THE CITY OF WINNIPEG**  
 WATER AND WASTE DEPARTMENT

DEACON CHEMICAL FEED BUILDING  
 UPS UPGRADES  
 SINGLE LINE DIAGRAM  
 NEW INSTALLATION

CITY DRAWING NUMBER: 1-0620C-E0002

SHEET: 001 REV: 00 SIZE: A1

|                |                    |
|----------------|--------------------|
| DRAWING NUMBER | REFERENCE DRAWINGS |
|----------------|--------------------|