



EXISTING CONFIGURATION

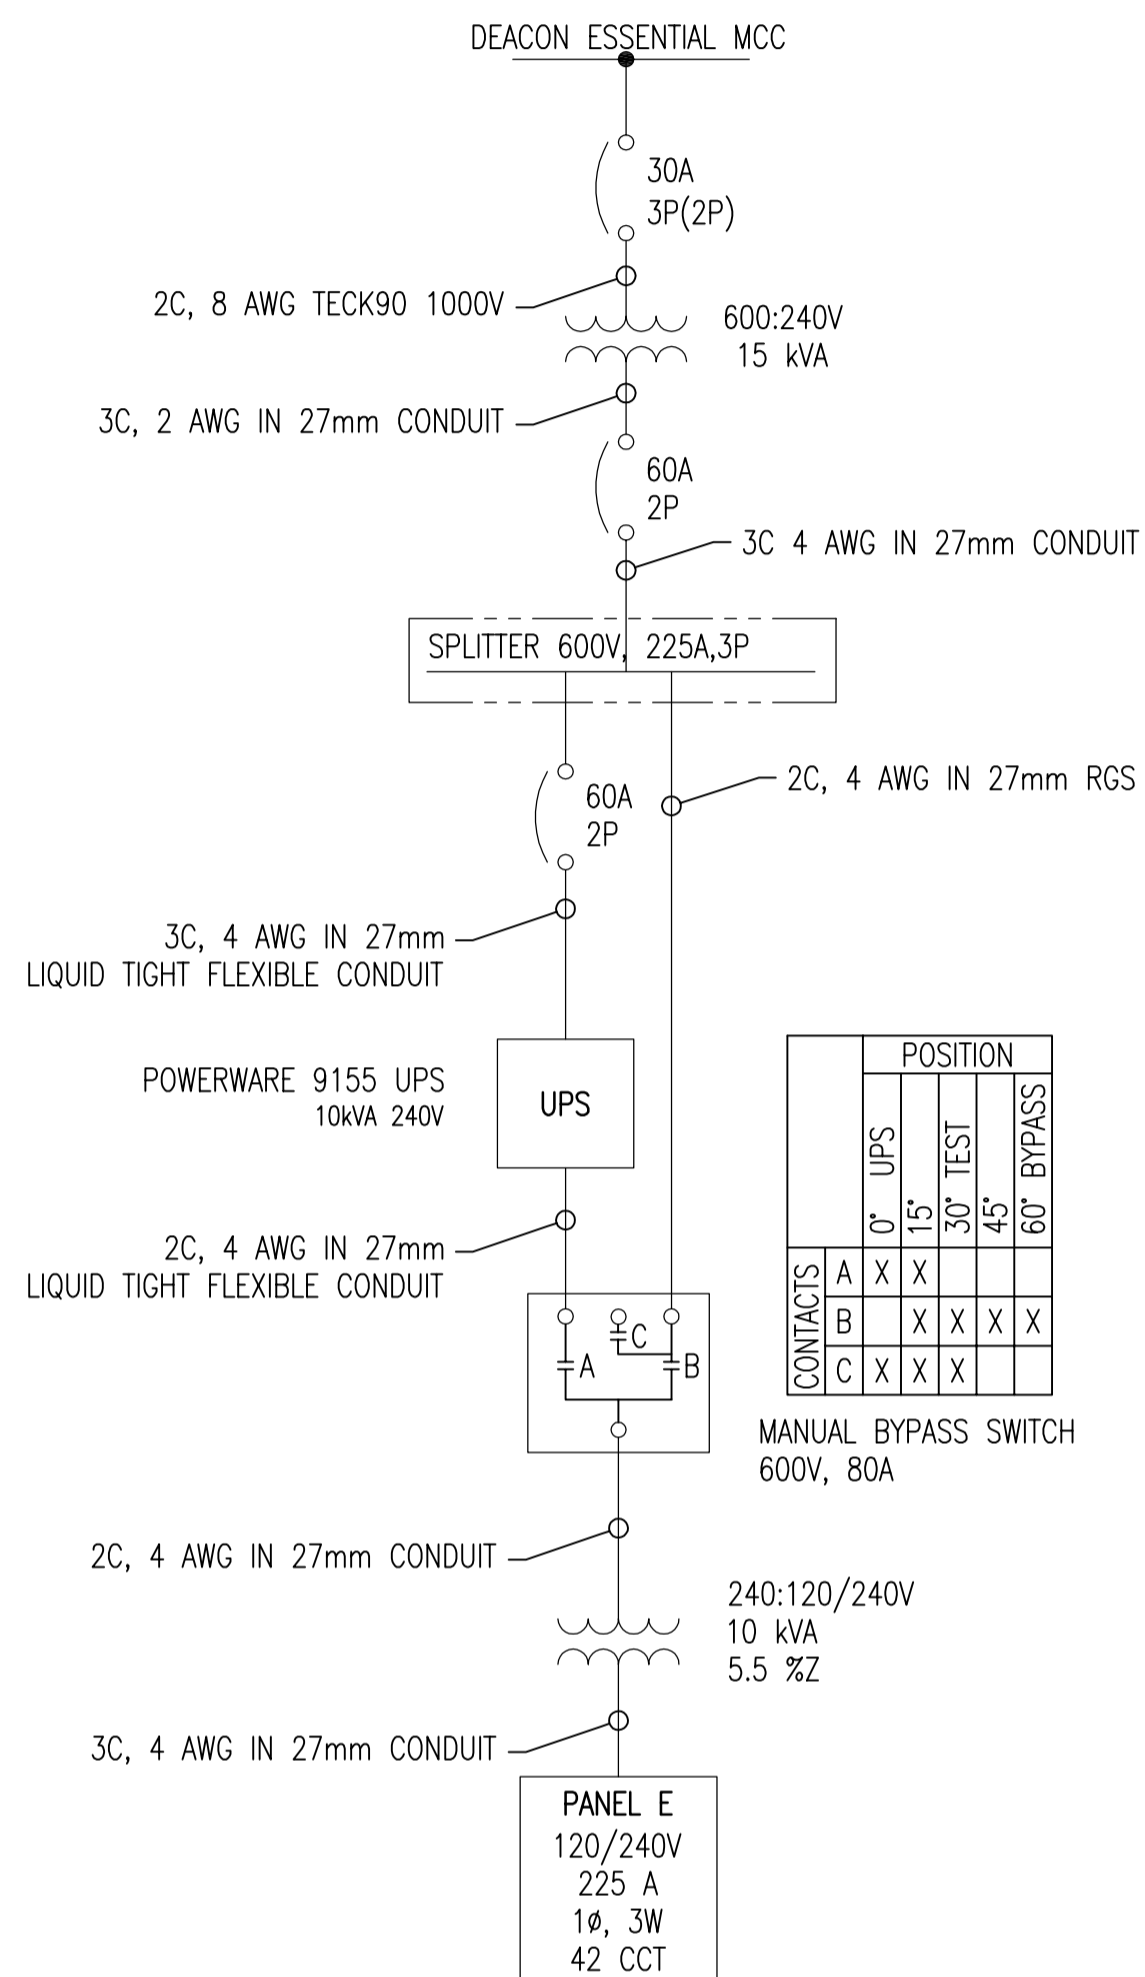

		POSITION				
		0'	15'	30'	45'	60'
CONTACTS	A	X	X	X	X	X
	B	X	X	X	X	X
	C	X	X	X	X	X

NEW CONFIGURATION

LEGEND	
LFMC	LIQUID TIGHT FLEXIBLE METAL CONDUIT
RGS	RIGID GALVANIZED STEEL CONDUIT

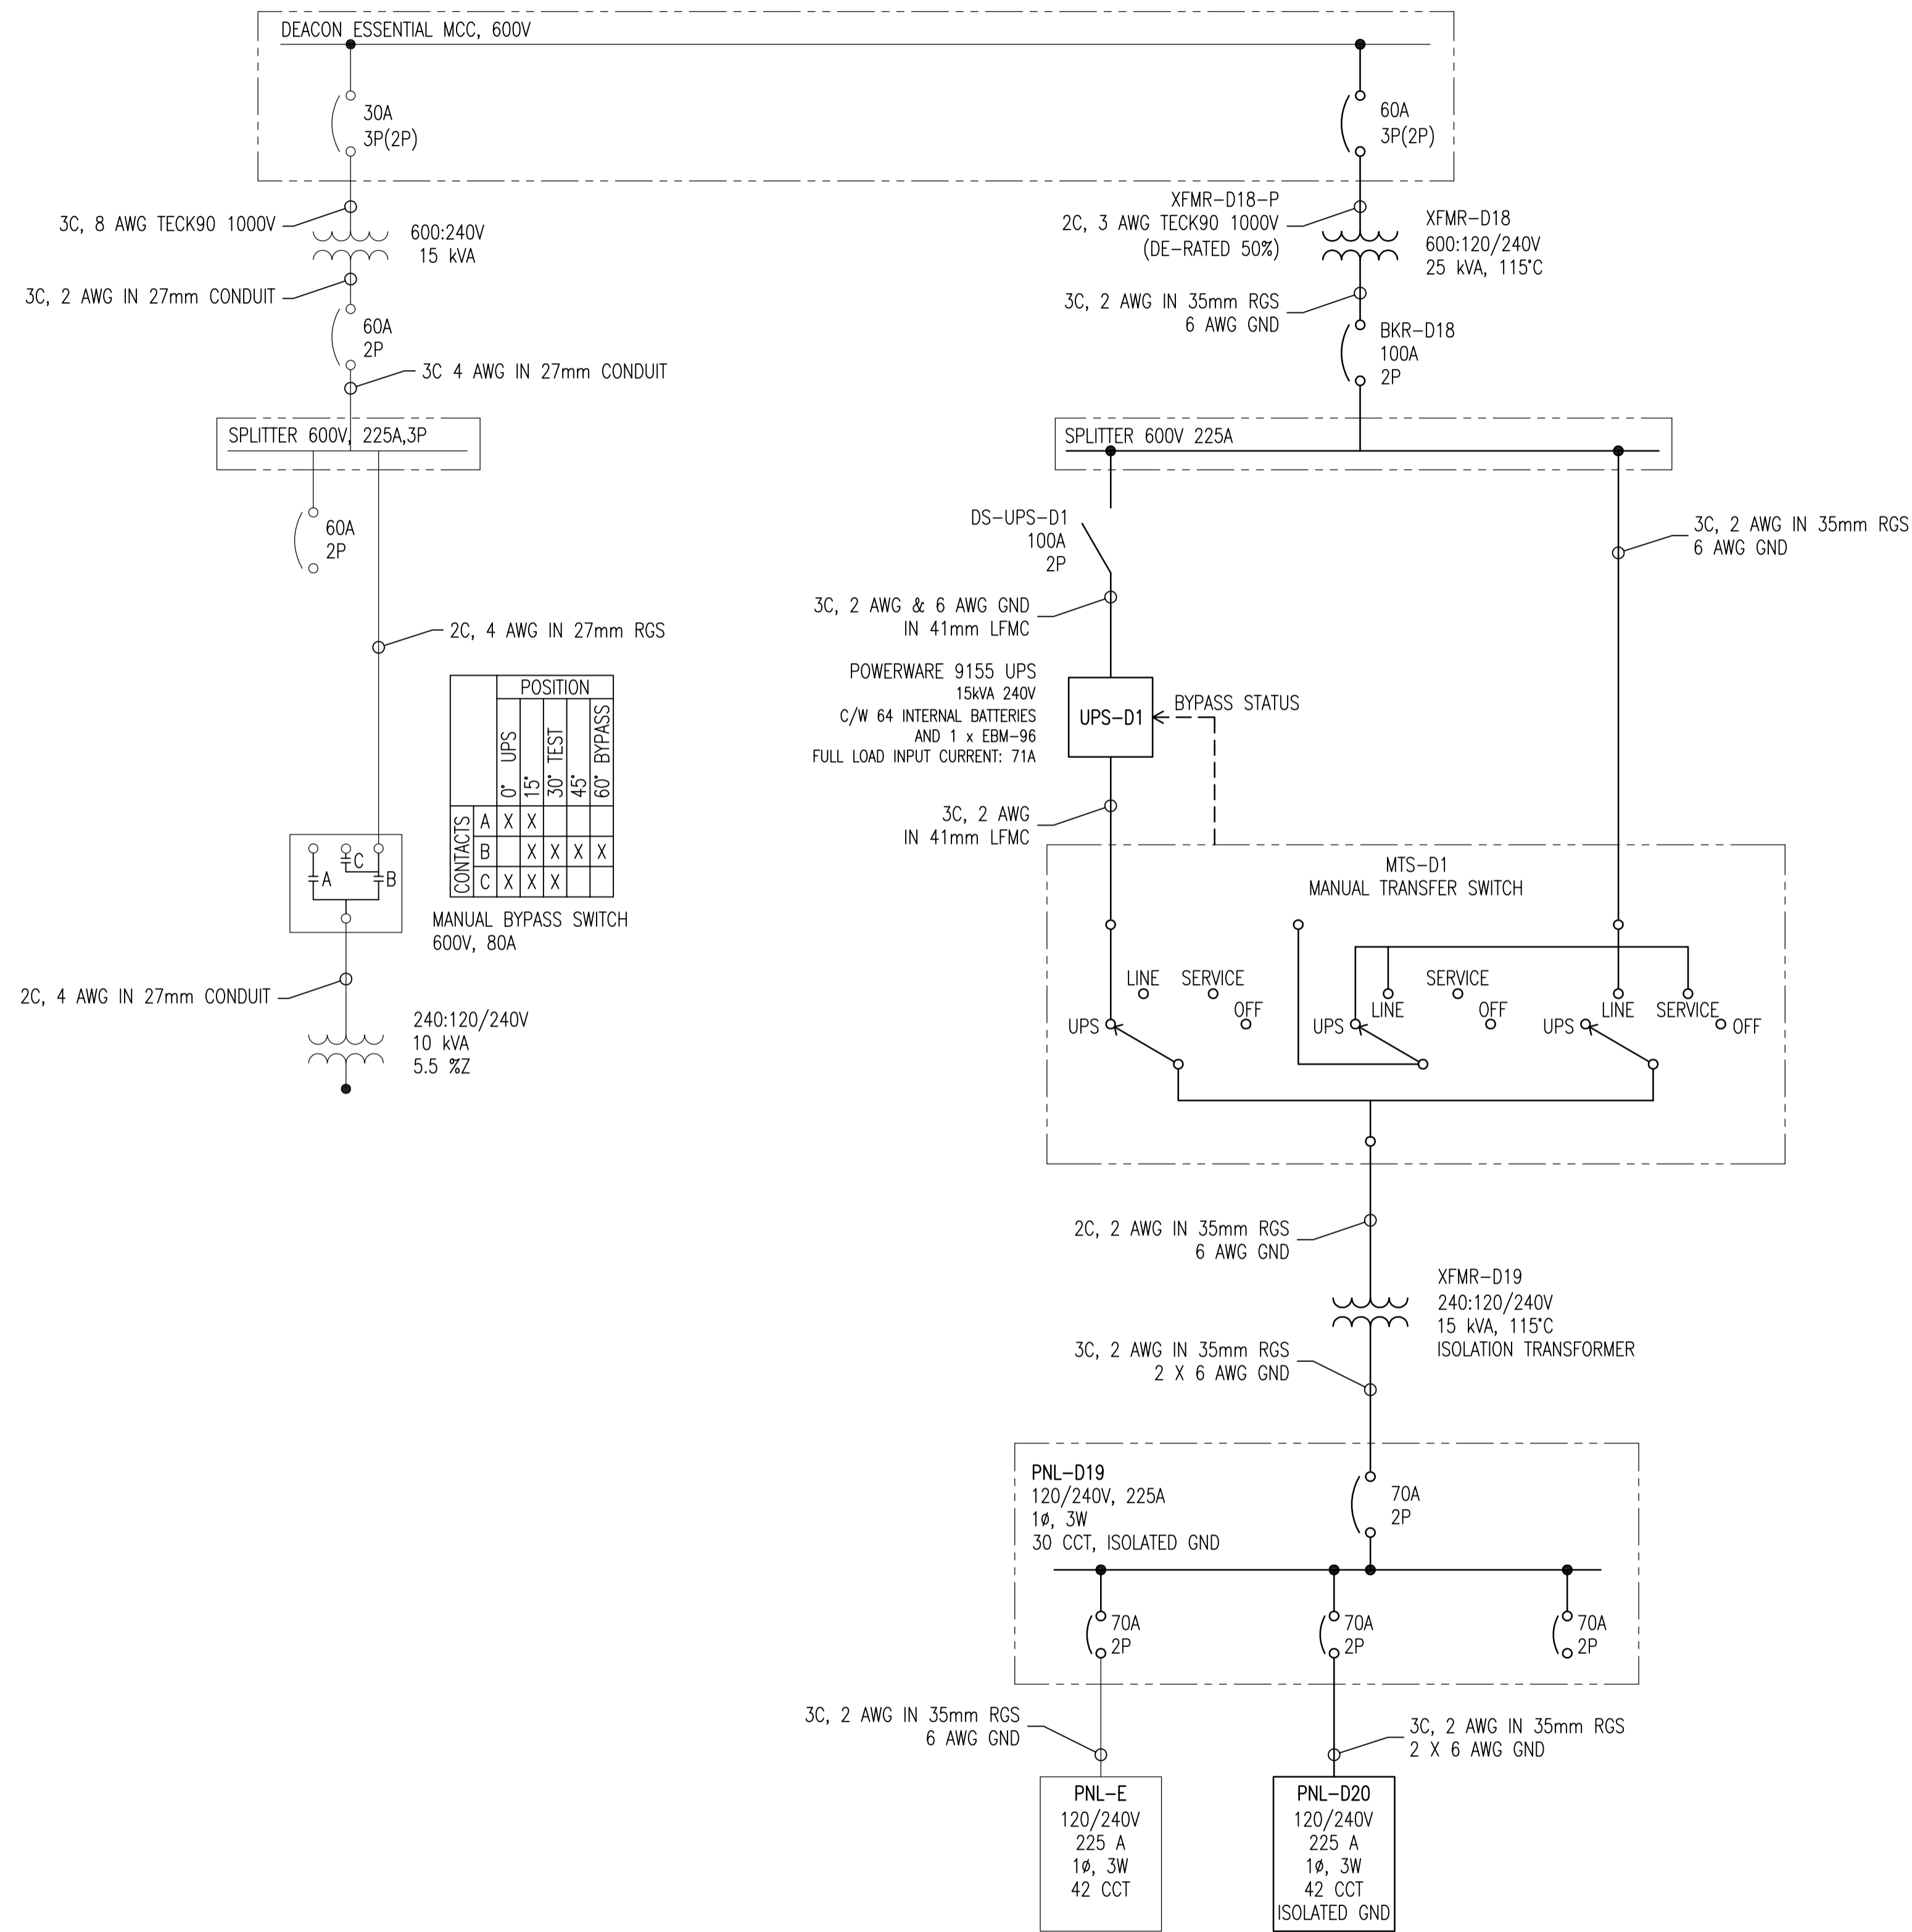

		POSITION				
		0'	15'	30'	45'	60'
CONTACTS	A	X	X	X	X	X
	B	X	X	X	X	X
	C	X	X	X	X	X

DRAWING NUMBER	REFERENCE DRAWINGS
----------------	--------------------



B.M. ELEV.	FIELD BOOK #:	 SNC-LAVALIN INC. 148 Nature Park Way Winnipeg, MB, Canada R3P 0X7 204-786-8080	ENGINEER'S SEAL
POSTED TO LBIS			DESIGNED BY C. REIMER CHECKED BY C. REIMER DRAWN BY A. OLIVER APPROVED BY C. REIMER HOR. SCALE NTS VERTICAL NTS RELEASED FOR CONSTRUCTION
0 ISSUED FOR TENDER	2008/01/08	DATE 2007/07/05	DATE
NO. REVISIONS	DATE	BY	FILENAME: 1-0620D-E0001-001-00.dwg

PRELIMINARY NOT TO BE USED FOR CONSTRUCTION	 THE CITY OF WINNIPEG WATER AND WASTE DEPARTMENT		
	DEACON BOOSTER PUMPING STATION UPS UPGRADES SINGLE LINE DIAGRAM REMOVALS & INSTALLATIONS		
CITY DRAWING NUMBER	SHEET	REV.	SIZE
1-0620D-E0001	001	0	A1