
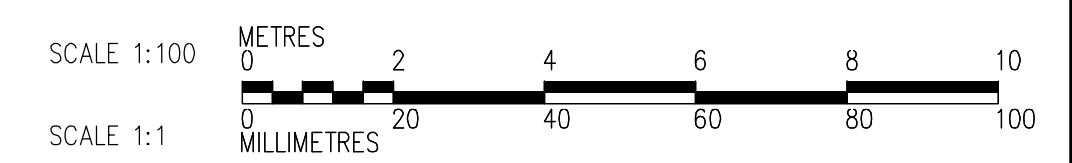


- NOTES:**
- SEE MCC #2A & #2B SINGLE LINE DIAGRAM AND DP-C11 & DP-C12 POWER DISTRIBUTION FOR 600V POWER DISTRIBUTION.
 - ALL 120V AND 208V LOADS ARE FED FROM LP-C11
 - PROVIDE STAIRWELL SMOKE DETECTORS AS SHOWN ON FIRE PROTECTION DRAWINGS

CABLE TRAY TAGGING
SEE DETAIL

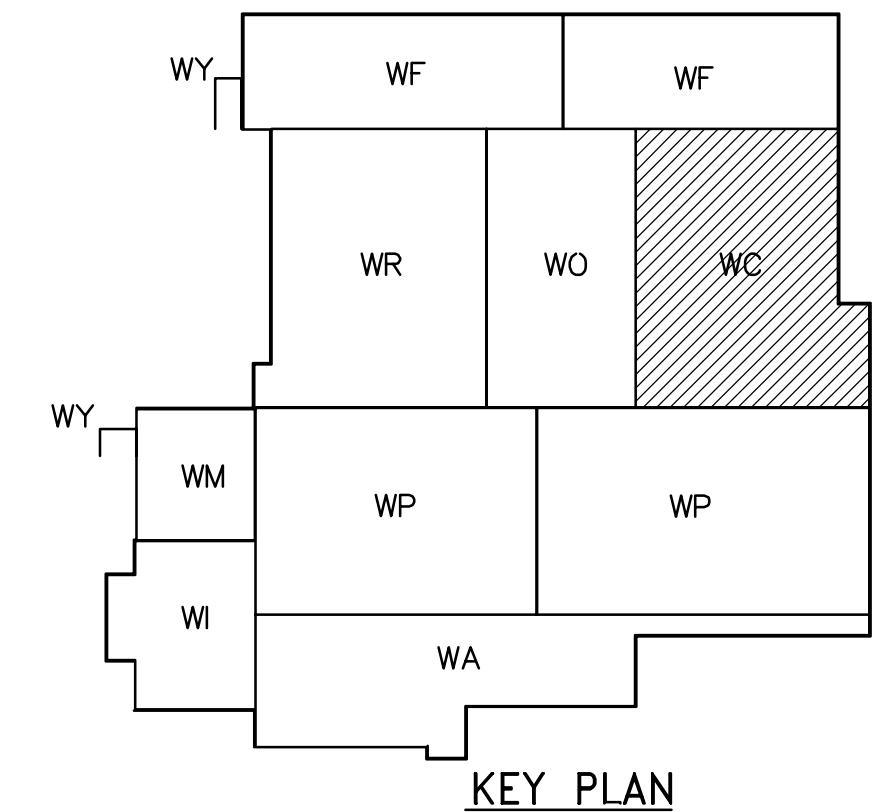

FIRST FLOOR FACILITY PLAN
1:100

<p>Certificate of Authorization CH2M HILL Canada Ltd. No. 1441 Expiry: April 30, 2007</p>	<p>B.M. ELEV.</p> <p>INFORMATION ONLY</p>		<p>Frederickson Cooper ARCHITECTS</p>	<p>1700 International Ltd. Company</p>	ENGINEER'S SEAL	<p>THE CITY OF WINNIPEG WATER AND WASTE DEPARTMENT ENGINEERING DIVISION</p>		
	DESIGNED BY: JT	CHECKED BY: ND			ORIGINAL SIGNED BY: L.D. LLEWELLYN		DATE: 2006/03/29	CITY FILE NUMBER
03 ISSUED FOR CONSTRUCTION 06/07/28 LL	02 742-2005 ADDENDUM 5 06/05/19 LL	01 742-2005 ADDENDUM 3 06/05/05 LL	00 ISSUED FOR TENDER 06/03/29 LL	SCALE: 1:100	APPROVED BY: AHL	RELEASED FOR CONSTRUCTION BY: R. SOROKOWSKI	DATE: 2006/03/29	SHEET OF
NO. REVISIONS DATE BY				DATE: 2005/07/08	DATE: 2006/03/29	CONSULTANT DRAWING NO. WC-E0111	ELECTRICAL CHEMICAL AREA FIRST FLOOR FACILITY PLAN	CITY DRAWING NUMBER 1-0601C-A-E011-001-030