
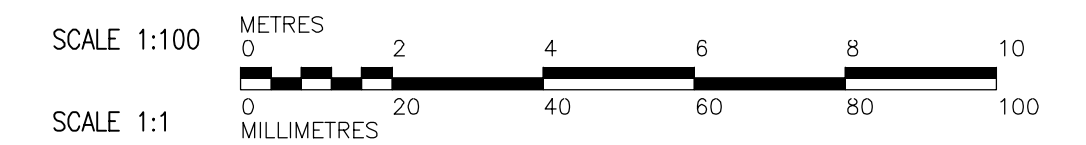


- NOTES:
1. PROVIDE FIRE DAMPER AT ALL DUCT PENETRATION THRU FLOOR.

SECOND FLOOR PLAN
1:100

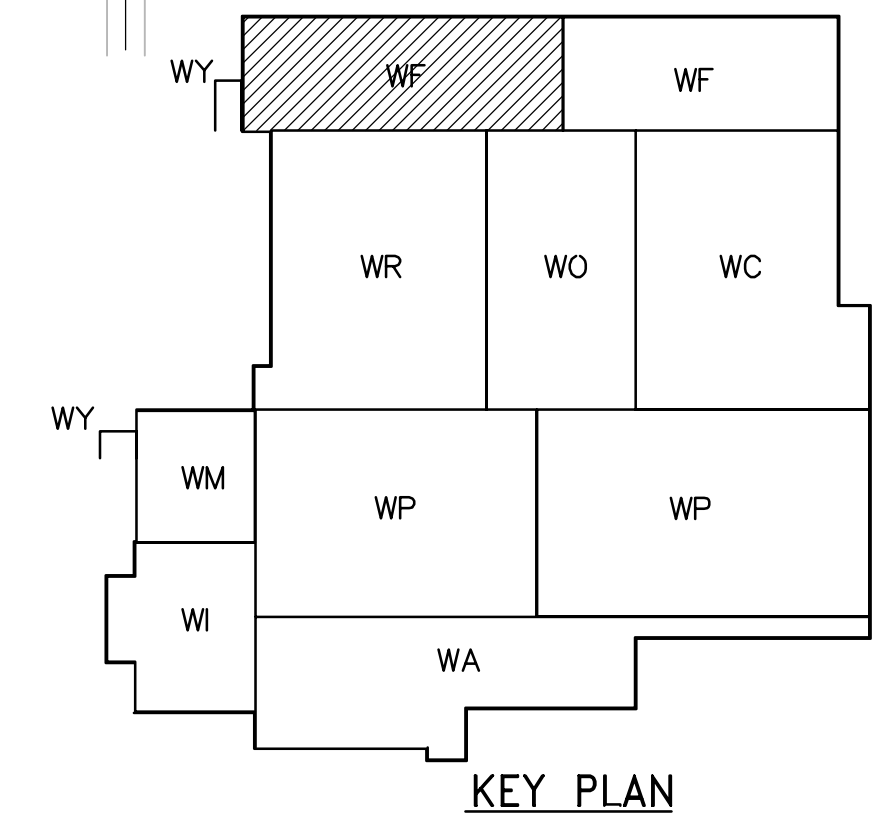

 Certificate of Authorization CH2M HILL Canada Ltd. No. 1441 Expiry: April 30, 2007	B.M. FLEV. INFORMATION ONLY		 Frederickson Cooper ARCHITECTS	 A Tyco International US Company	ENGINEER'S SEAL ORIGINAL SIGNED BY D.K. CUDDINGTON 2006/03/29	 THE CITY OF WINNIPEG WATER AND WASTE DEPARTMENT ENGINEERING DIVISION WATER TREATMENT PLANT FILTRATION MECHANICAL AND ELECTRICAL HVAC FILTRATION AREA 1 SECOND FLOOR PLAN	CITY FILE NUMBER SHEET OF									
	<table border="1"> <tr> <td>01</td> <td>ISSUED FOR CONSTRUCTION</td> <td>06/07/28</td> <td>TT</td> </tr> <tr> <td>00</td> <td>ISSUED FOR TENDER</td> <td>06/03/29</td> <td>TT</td> </tr> <tr> <td>NO.</td> <td>REVISIONS</td> <td>DATE</td> <td>BY</td> </tr> </table>	01	ISSUED FOR CONSTRUCTION	06/07/28	TT		00	ISSUED FOR TENDER	06/03/29	TT	NO.	REVISIONS	DATE	BY	DESIGNED BY TT DRAWN BY AM SCALE: 1:100	CHECKED BY DL APPROVED BY AHL RELEASED FOR CONSTRUCTION BY: R. SOROKOWSKI DATE 2006/03/29
01	ISSUED FOR CONSTRUCTION	06/07/28	TT													
00	ISSUED FOR TENDER	06/03/29	TT													
NO.	REVISIONS	DATE	BY													