
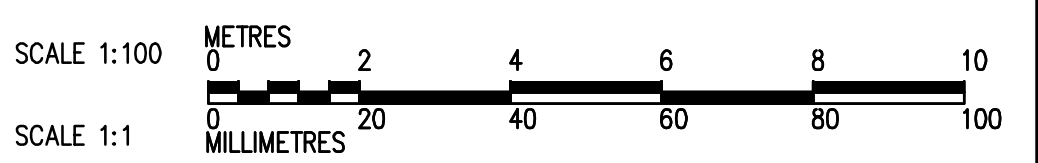


THIRD FLOOR PLAN
1:100

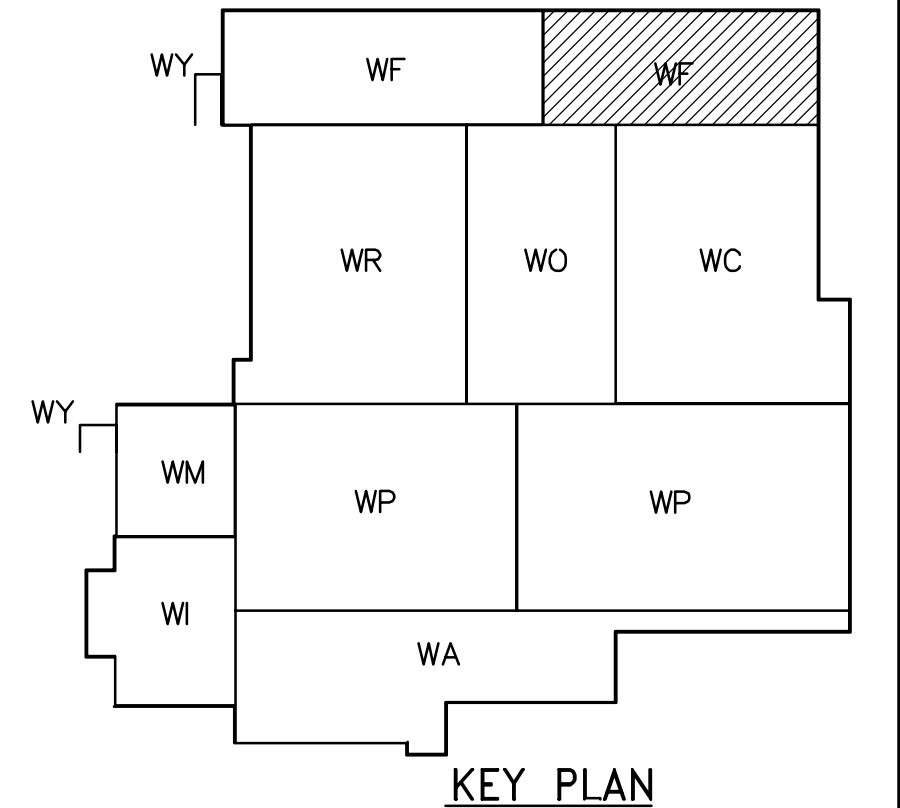

<p>APEGM Certificate of Authorization CH2M HILL Canada Ltd. No. 1441 Expiry: April 30, 2007</p>	<p>INFORMATION ONLY</p> <table border="1"> <tr> <th>NO.</th> <th>REVISIONS</th> <th>DATE</th> <th>BY</th> </tr> <tr> <td>02</td> <td>ISSUED FOR CONSTRUCTION</td> <td>06/07/28</td> <td>SW</td> </tr> <tr> <td>01</td> <td>742-2005 ADDENDUM 5</td> <td>06/05/19</td> <td>SW</td> </tr> <tr> <td>00</td> <td>ISSUED FOR TENDER</td> <td>06/03/29</td> <td>SW</td> </tr> </table>	NO.	REVISIONS	DATE	BY	02	ISSUED FOR CONSTRUCTION	06/07/28	SW	01	742-2005 ADDENDUM 5	06/05/19	SW	00	ISSUED FOR TENDER	06/03/29	SW	<p>CH2M HILL Frederickson Cooper ARCHITECTS</p> <p>DESIGNED BY: JZ/SW DRAWN BY: JMcP SCALE: 1:100</p>	<p>EarthTech A Tyco International Ltd. Company</p> <p>CHECKED BY: DL APPROVED BY: AHL RELEASED FOR CONSTRUCTION BY: R. SOROKOWSKI</p> <p>DATE: 2005/08/02</p>	<p>ENGINEER'S SEAL</p> <p>ORIGINAL SIGNED BY: D.K. CUDDINGTON DATE: 2006/03/29</p> <p>CONSULTANT DRAWING NO.: WF-H0134</p>	<p>THE CITY OF WINNIPEG WATER AND WASTE DEPARTMENT ENGINEERING DIVISION</p> <p>WATER TREATMENT PLANT FILTRATION MECHANICAL AND ELECTRICAL</p> <p>PLUMBING FILTRATION AREA 2 THIRD FLOOR PLAN</p>	<p>CITY FILE NUMBER</p>
		NO.	REVISIONS	DATE	BY																	
02	ISSUED FOR CONSTRUCTION	06/07/28	SW																			
01	742-2005 ADDENDUM 5	06/05/19	SW																			
00	ISSUED FOR TENDER	06/03/29	SW																			
<p>SHEET OF</p>	<p>CITY DRAWING NUMBER 1-0601F-A-H0134-001-020</p>																					