
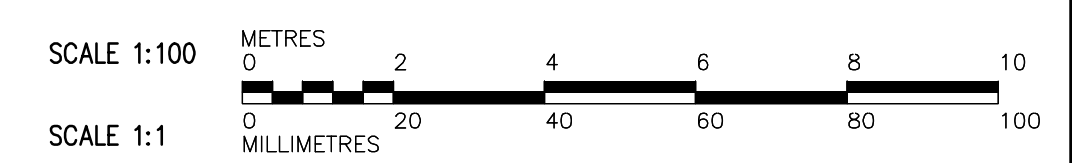


NOTES:
1. SUPPLY BY OTHERS, INSTALLATION BY CONTRACTOR.

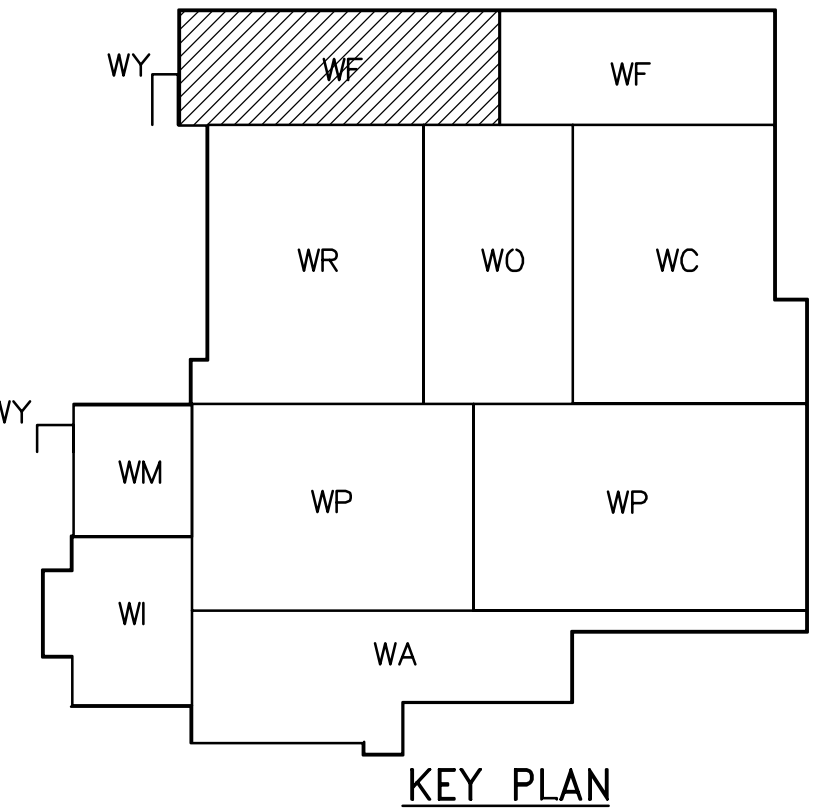

<p>APEGM Certificate of Authorization CH2M HILL Canada Ltd. No. 1441 Expiry: April 30, 2007</p>	<p>INFORMATION ONLY</p>	<p>CH2M HILL Frederickson Cooper ARCHITECTS</p>	<p>EarthTech A Tyco International US Company</p>	<p>ENGINEER'S SEAL</p> <p>ORIGINAL SIGNED BY P. WOBMA 2006/03/29</p>	<p>THE CITY OF WINNIPEG WATER AND WASTE DEPARTMENT ENGINEERING DIVISION</p>
				<p>CONSULTANT DRAWING NO. WF-M0131</p>	
<p>DESIGNED BY: TB CHECKED BY: LS</p> <p>DRAWN BY: TAR/EK APPROVED BY: AHL</p> <p>SCALE: 1:100 RELEASED FOR CONSTRUCTION BY: R. SOROKOWSKI</p> <p>DATE: 2005/07/08 DATE: 2006/03/29</p>				<p>PROCESS MECHANICAL FILTRATION AREA 1 THIRD FLOOR PLAN</p>	
<p>01 ISSUED FOR CONSTRUCTION 06/07/28 TB</p> <p>00 ISSUED FOR TENDER 06/03/29 TB</p> <p>NO. REVISIONS DATE BY</p>				<p>CITY FILE NUMBER</p> <p>SHEET OF</p> <p>CITY DRAWING NUMBER 1-0601F-A-M0131-001-010</p>	