
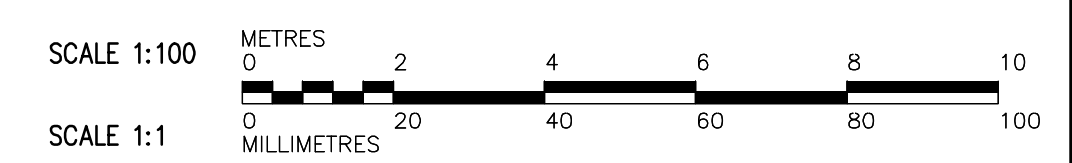


PLAN AT EL 245.00  
1:100

**NOTES:**

1. SUPPLY BY OTHERS, INSTALLATION BY CONTRACTOR.

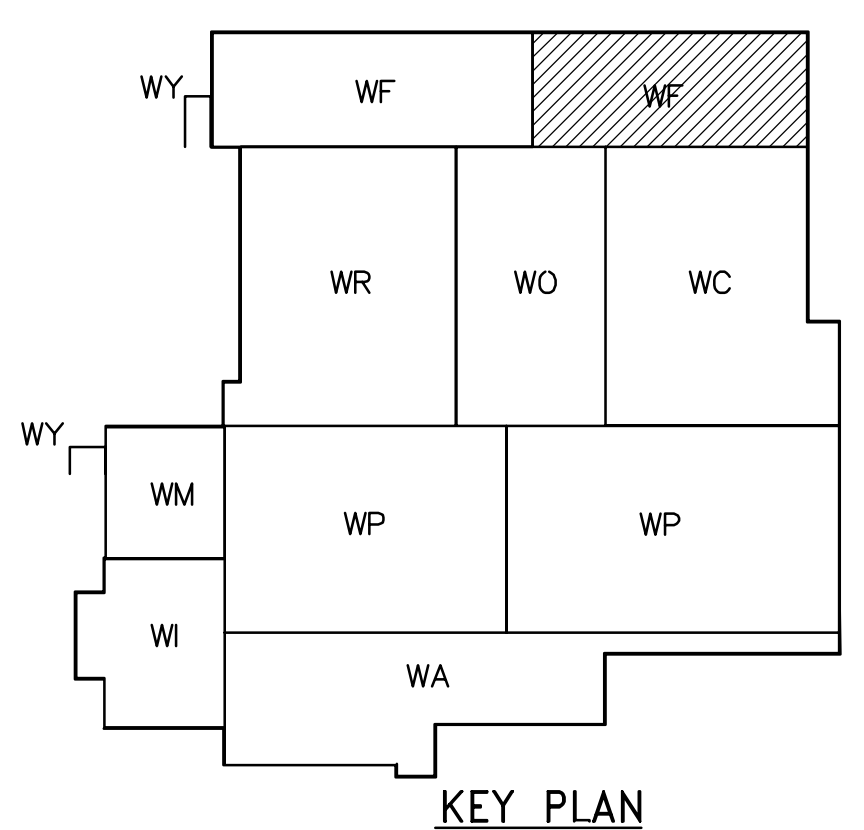

 Certificate of Authorization CH2M HILL Canada Ltd. No. 1441 Expiry: April 30, 2007	<b>INFORMATION ONLY</b>		B.M. ELEV. CH2M HILL Frederickson Cooper ARCHITECTS	EarthTech A Tyco International Ltd. Company	ENGINEER'S SEAL ORIGINAL SIGNED BY P. WOBMA 2006/03/29	THE CITY OF WINNIPEG WATER AND WASTE DEPARTMENT ENGINEERING DIVISION WATER TREATMENT PLANT FILTRATION MECHANICAL AND ELECTRICAL PROCESS MECHANICAL FILTRATION AREA 2 THIRD FLOOR PLAN	CITY FILE NUMBER
	DESIGNED BY: TB DRAWN BY: TAR/EK SCALE: 1:100 DATE: 2005/07/08	CHECKED BY: LS APPROVED BY: AHL RELEASED FOR CONSTRUCTION BY: R. SOROKOWSKI DATE: 2006/03/29	CONSULTANT DRAWING NO. WF-M0132	SHEET OF CITY DRAWING NUMBER 1-0601F-A-M0132-001-010			
01 ISSUED FOR CONSTRUCTION 06/07/28 TB 00 ISSUED FOR TENDER 06/03/29 TB NO. REVISIONS DATE BY			DATE 2005/07/08	DATE 2006/03/29			