




LOWER LEVEL PLAN
1:100

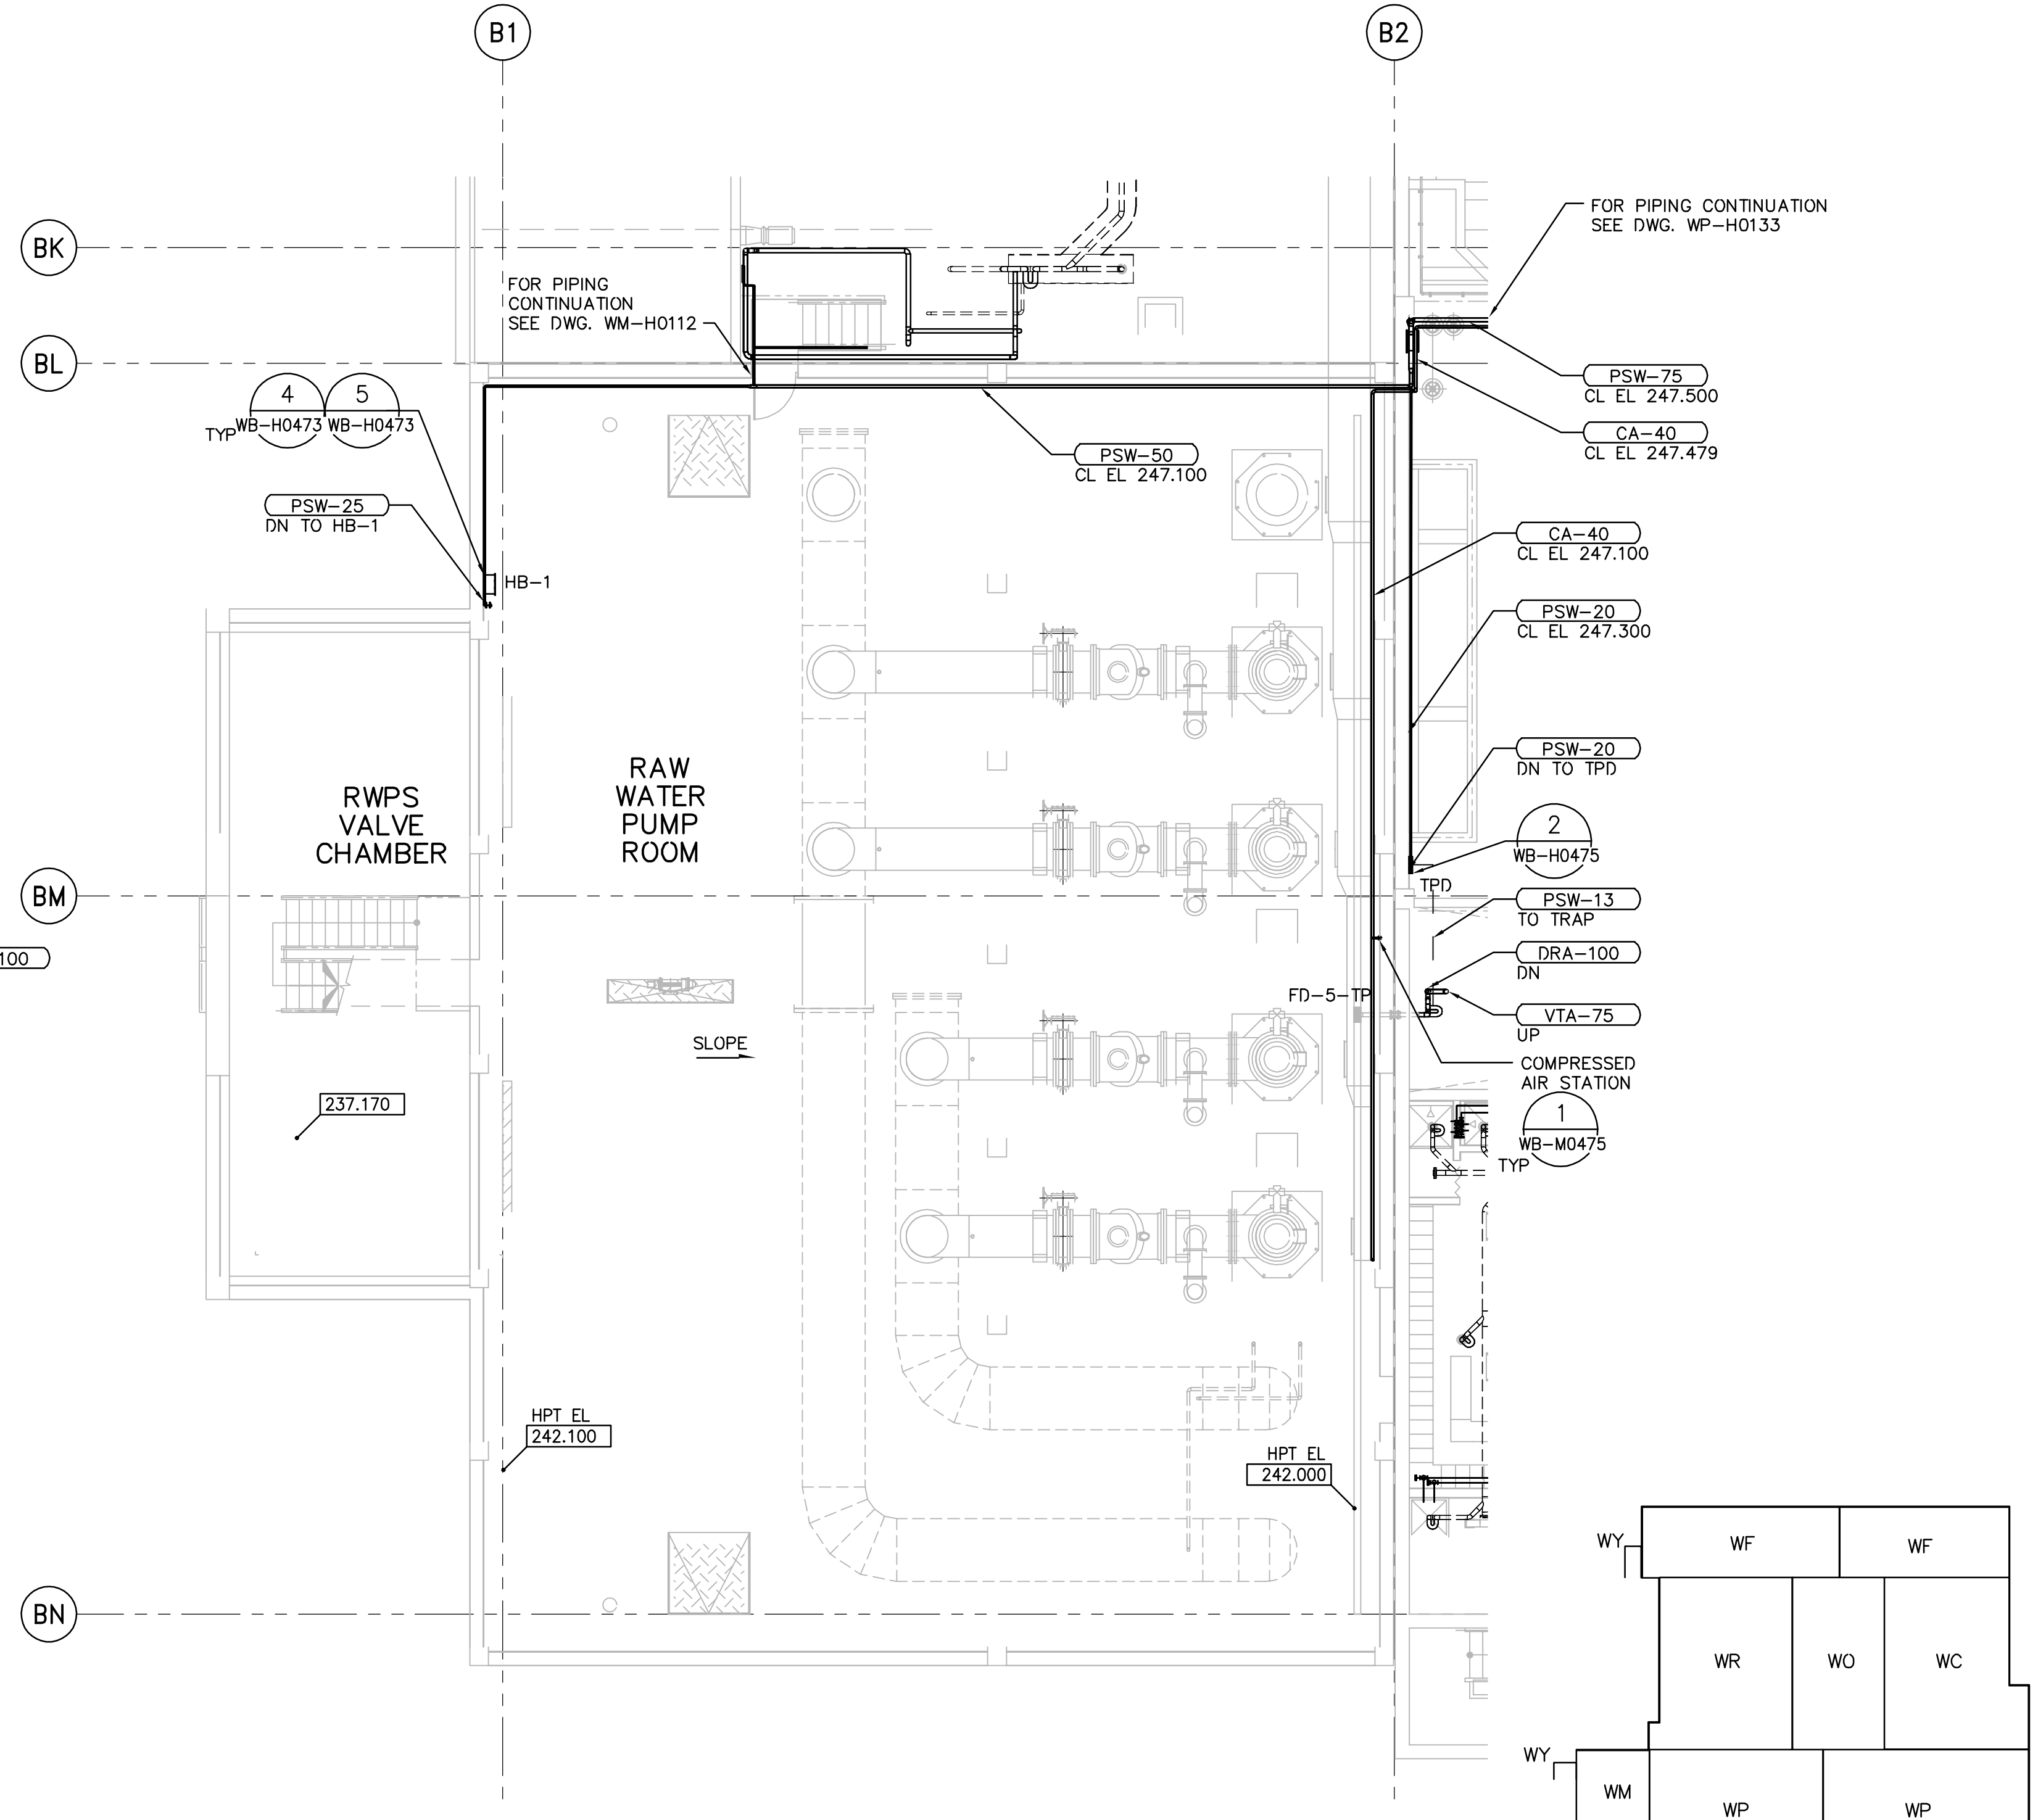

THIRD FLOOR PLAN
1:100

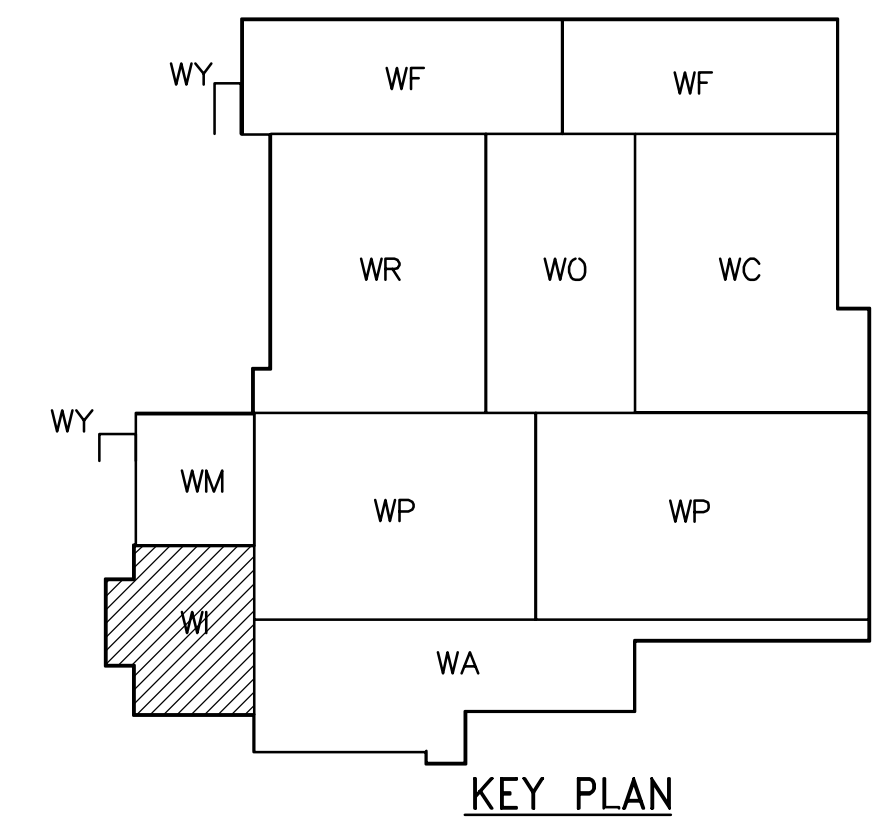

KEY PLAN

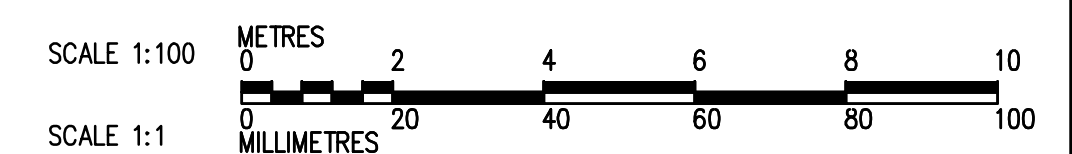

<p>Certificate of Authorization CH2M HILL Canada Ltd. No. 1441 Expiry: April 30, 2007</p>	<p>INFORMATION ONLY</p>		<p>Frederickson Cooper ARCHITECTS</p>	<p>EarthTech A Tyco International US Company</p>	ENGINEER'S SEAL	<p>THE CITY OF WINNIPEG WATER AND WASTE DEPARTMENT ENGINEERING DIVISION</p>	CITY FILE NUMBER
	DESIGNED BY JZ/SW	CHECKED BY DL			ORIGINAL SIGNED BY D.K. CUDDINGTON		2006/03/29
01 ISSUED FOR CONSTRUCTION 06/07/28 SW	00 ISSUED FOR TENDER 06/03/29 SW	SCALE: 1:100	RELEASED FOR CONSTRUCTION BY: R. SOROKOWSKI	CONSULTANT DRAWING NO. WI-H0122	PLUMBING RAW WATER PUMP STATION LOWER LEVEL AND THIRD FLOOR PLANS	CITY DRAWING NUMBER 1-06011-A-H0122-001-010	
NO. REVISIONS	DATE BY	DATE 2005/08/02	DATE 2006/03/29				