




FIRST FLOOR PLAN
1:100

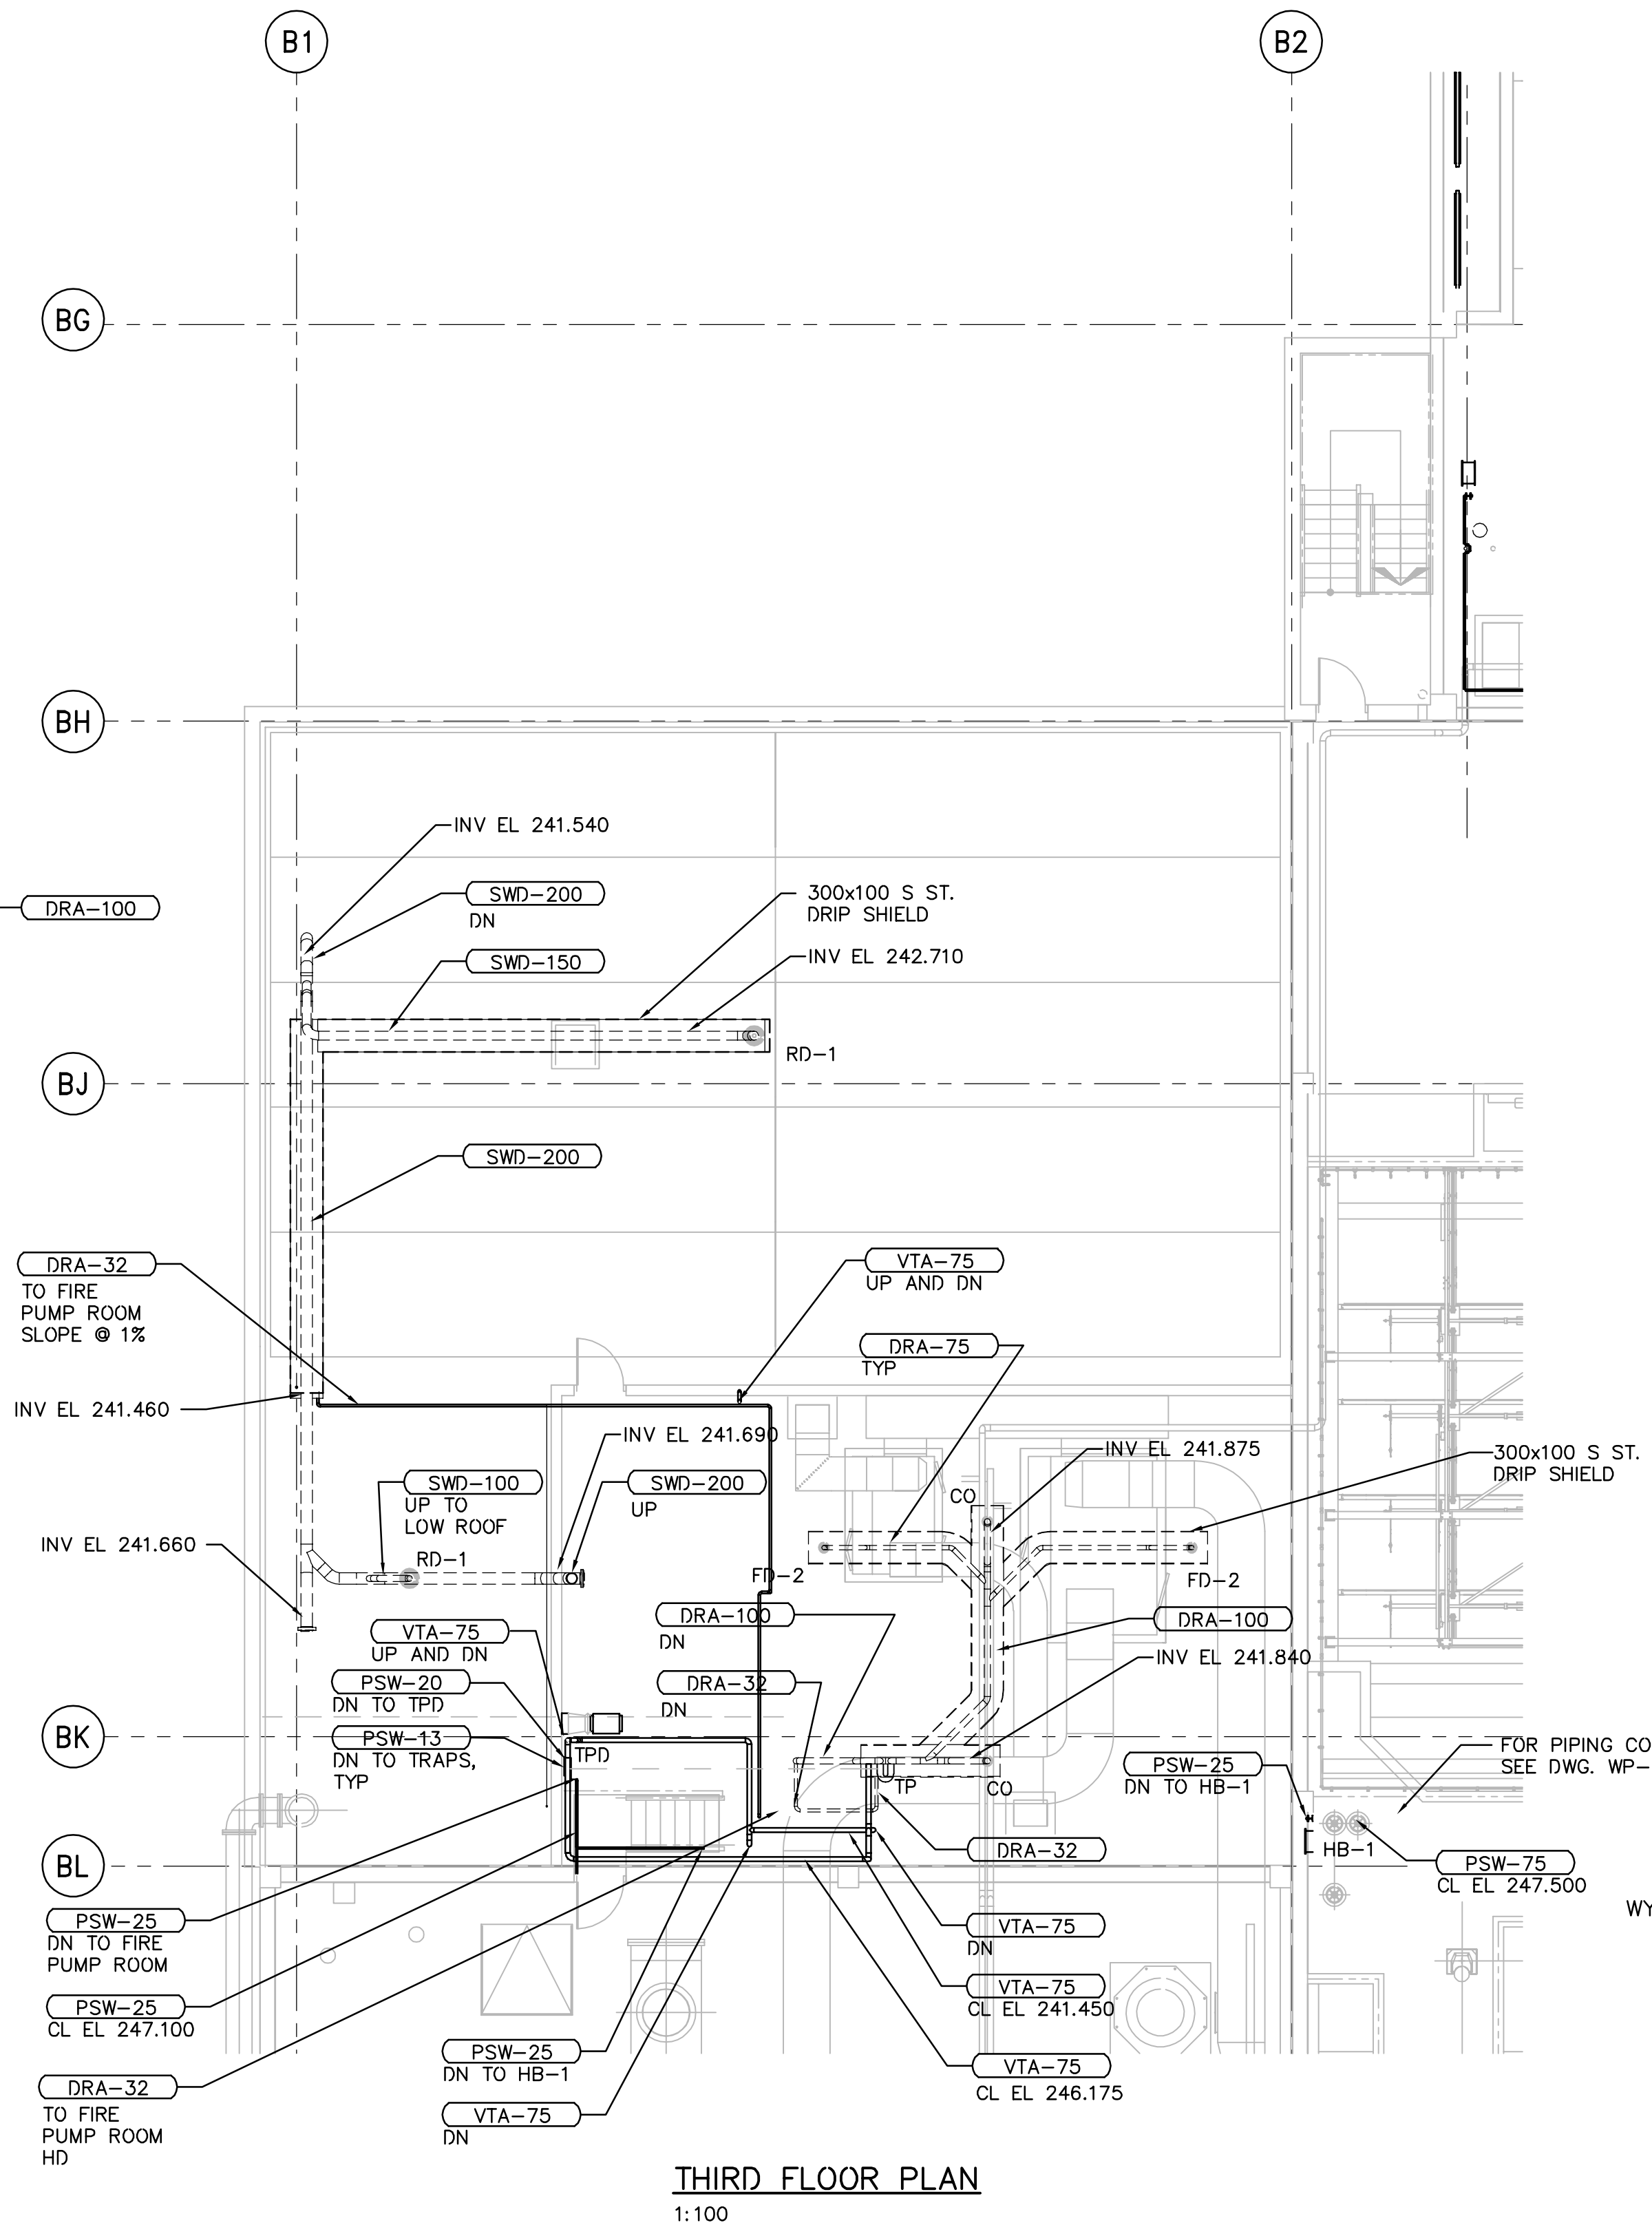

THIRD FLOOR PLAN
1:100

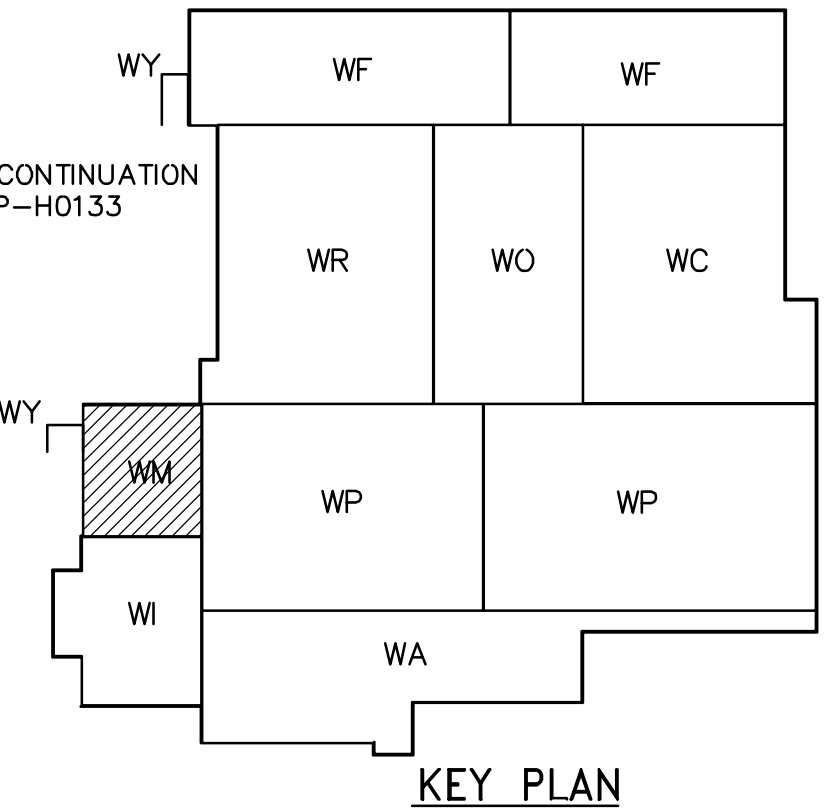

KEY PLAN

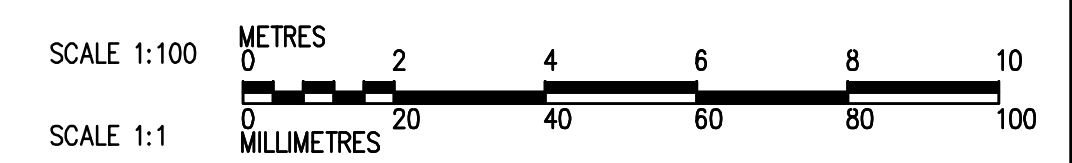

<p>APEGM Certificate of Authorization CH2M HILL Canada Ltd. No. 1441 Expiry: April 30, 2007</p>	<p>B.M.</p> <p>INFORMATION ONLY</p>	<p>CH2M HILL Frederickson Cooper ARCHITECTS</p>	<p>EarthTech A Tyco International US Company</p>	ENGINEER'S SEAL	<p>THE CITY OF WINNIPEG WATER AND WASTE DEPARTMENT ENGINEERING DIVISION</p>
				<p>ORIGINAL SIGNED BY D.K. CUDDINGTON 2006/03/29</p>	
		<p>DESIGNED BY: JZ/SW DRAWN BY: JMcP SCALE: 1:100</p>	<p>CHECKED BY: SW APPROVED BY: AHL RELEASED FOR CONSTRUCTION BY: R. SOROKOWSKI</p>	<p>CONSULTANT DRAWING NO. WM-H0112</p>	<p>CITY FILE NUMBER</p> <p>SHEET OF</p> <p>CITY DRAWING NUMBER 1-0601M-A-H0112-001-020</p>
		<p>02 ISSUED FOR CONSTRUCTION 06/07/28 SW 01 742-2005 ADDENDUM 5 06/05/19 SW 00 ISSUED FOR TENDER 06/03/29 SW</p>	<p>DATE 2005/10/18 DATE 2006/03/29</p>		<p>PLUMBING FIRE PUMP AND ELECTRICAL ROOM FIRST FLOOR AND THIRD FLOOR PLANS</p>