
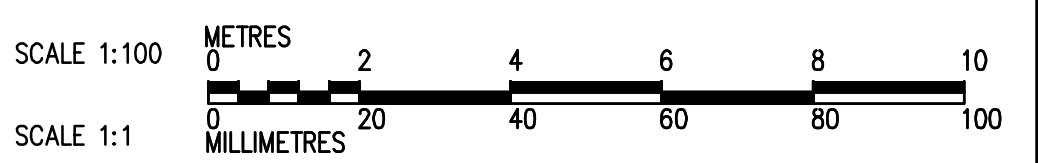


THIRD FLOOR PLAN
1:100

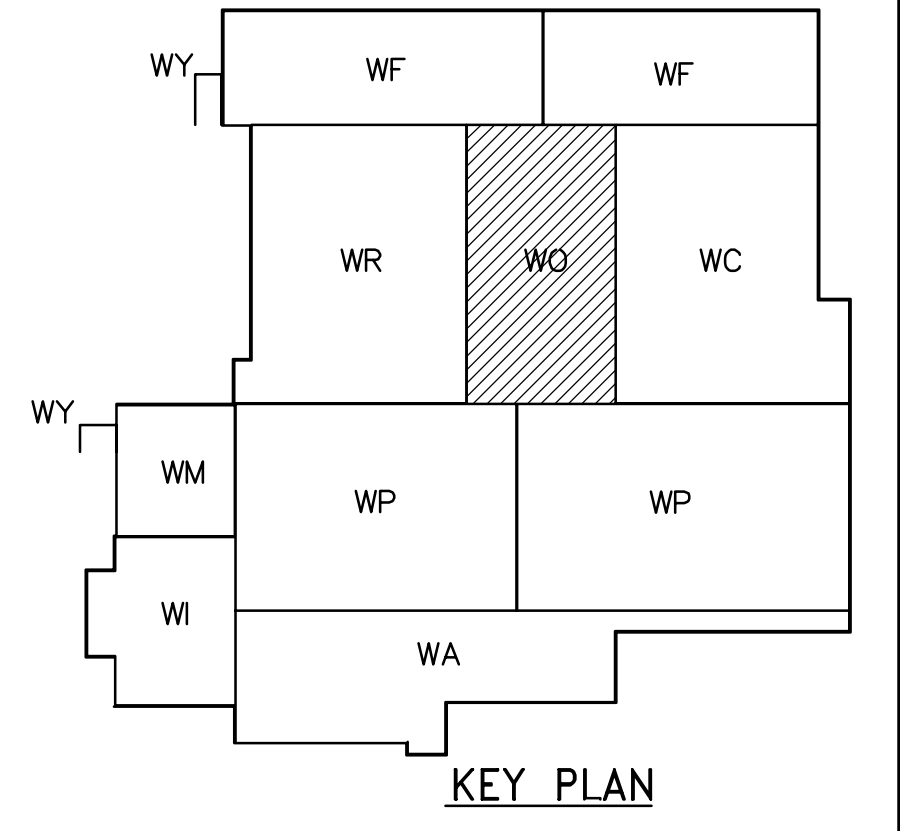

<p>APEGM Certificate of Authorization CH2M HILL Canada Ltd. No. 1441 Expiry: April 30, 2007</p>	<p>B.M. INFORMATION ONLY</p>		<p>Frederickson Cooper ARCHITECTS</p>	<p>EarthTech A Tyco International US Company</p>	<p>ENGINEER'S SEAL</p> <p>ORIGINAL SIGNED BY D.K. CUDDINGTON 2006/03/29</p>	<p>THE CITY OF WINNIPEG WATER AND WASTE DEPARTMENT ENGINEERING DIVISION</p>
	<p>DESIGNED BY: JZ/SW DRAWN BY: JMcP SCALE: 1:100</p>	<p>CHECKED BY: DL APPROVED BY: AHL RELEASED FOR CONSTRUCTION BY: R. SOROKOWSKI</p>	<p>CONSULTANT DRAWING NO. WO-H0132</p>	<p>WATER TREATMENT PLANT OZONE MECHANICAL AND ELECTRICAL</p>	<p>CITY FILE NUMBER</p> <p>SHEET OF</p> <p>CITY DRAWING NUMBER 1-06010-A-H0132-001-020</p>	
<p>02 ISSUED FOR CONSTRUCTION 06/07/28 SW 01 742-2005 ADDENDUM 5 06/05/19 SW 00 ISSUED FOR TENDER 06/03/29 SW</p>		<p>NO. REVISIONS DATE BY DATE 2005/08/02 DATE 2006/03/29</p>	<p>PLUMBING OZONATION AREA THIRD FLOOR PLAN</p>			