
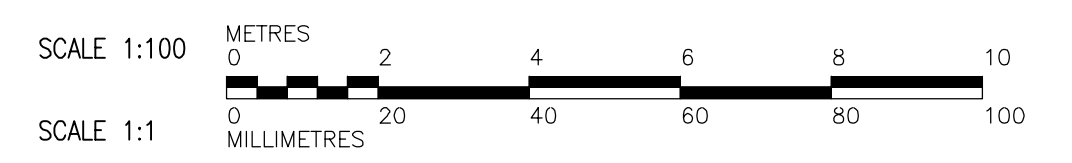


- NOTES:
- REFER TO SCHEMATIC DRAWING WB-H0505 FOR DETAIL OF HYDRONIC PIPING CONNECTION.
 - PROVIDE FIRE DAMPER AT ALL DUCT PENETRATION THRU FLOOR.
 - PROVIDE DRIP LEG ON GAS PIPES AS REQUIRED BY APPLICABLE GAS CODE.

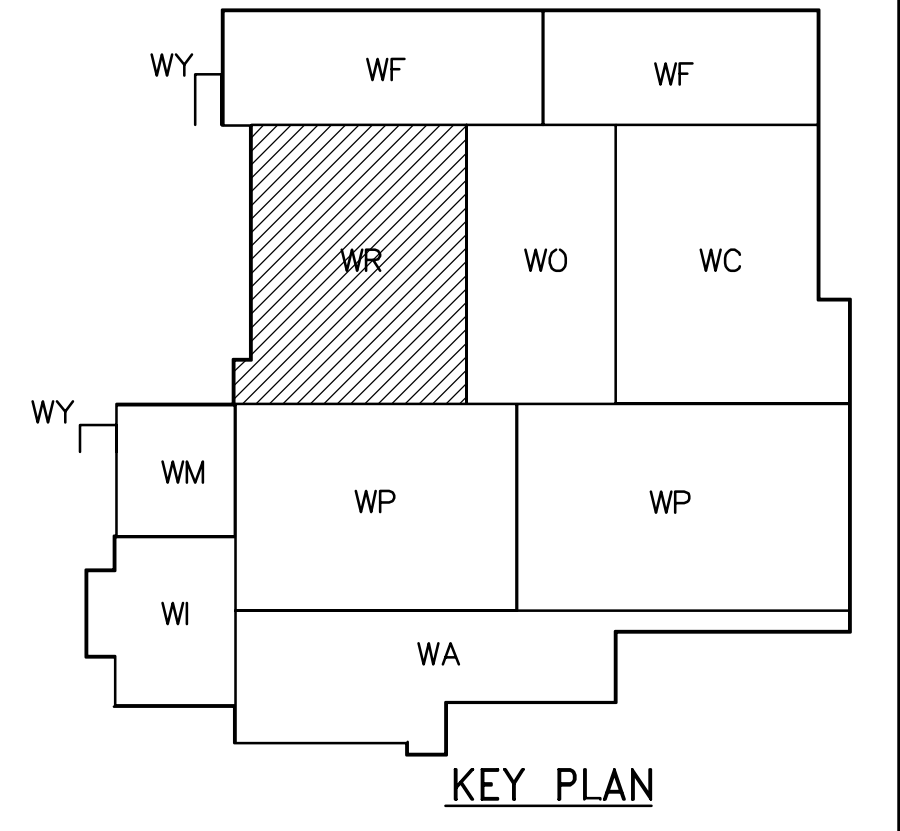

THIRD FLOOR PLAN
1:100

STAIRWELL NO.4

<p>Certificate of Authorization CH2M HILL Canada Ltd. No. 1441 Expiry: April 30, 2007</p>	<p>B.M.</p> <p>INFORMATION ONLY</p>		<p>Frederickson Cooper ARCHITECTS</p>	<p>A 100 International Ltd. Company</p>	ENGINEER'S SEAL	<p>THE CITY OF WINNIPEG WATER AND WASTE DEPARTMENT ENGINEERING DIVISION</p>
	DESIGNED BY TT	CHECKED BY DL			ORIGINAL SIGNED BY D.K. CUDDINGTON	
<p>01 ISSUED FOR CONSTRUCTION 06/07/28 TT</p> <p>00 ISSUED FOR TENDER 06/03/29 TT</p> <p>NO. REVISIONS DATE BY</p>	<p>SCALE: 1:100</p> <p>RELEASED FOR CONSTRUCTION BY: R. SOROKOWSKI</p> <p>DATE 2005/07/04 DATE 2006/03/29</p>	<p>APPROVED BY AM</p> <p>APPROVED BY AHL</p>	<p>DESIGNED BY TT</p> <p>CHECKED BY DL</p> <p>APPROVED BY AHL</p>	<p>THE CITY OF WINNIPEG WATER AND WASTE DEPARTMENT ENGINEERING DIVISION</p> <p>WATER TREATMENT PLANT RESIDUALS HANDLING MECHANICAL AND ELECTRICAL</p> <p>HVAC RESIDUALS HANDLING AREA THIRD FLOOR PLAN</p>	<p>CITY FILE NUMBER</p> <p>SHEET OF</p> <p>CITY DRAWING NUMBER 1-0601R-A-H0131-001-010</p>	