
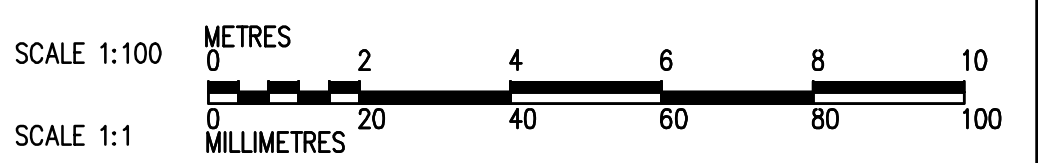


THIRD FLOOR PLAN
1:100

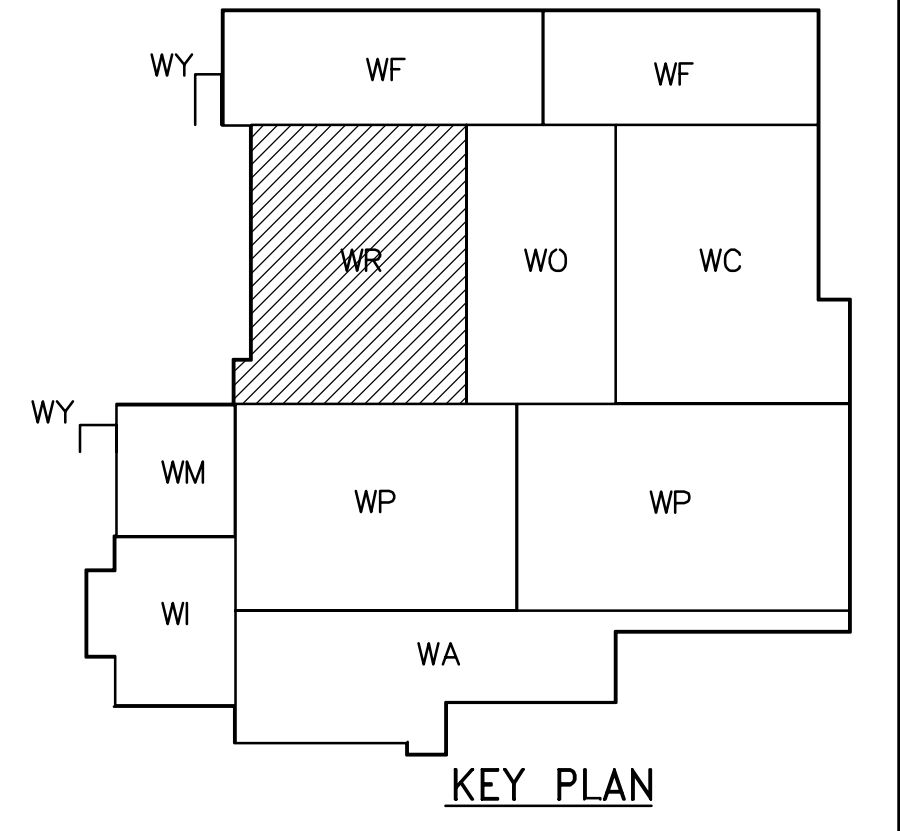

| | | | | | | |
|--|--|------------------------------------|--|---|---|------------------------------|
| APEGM Certificate of Authorization CH2M HILL Canada Ltd. No. 1441 Expiry: April 30, 2007 | INFORMATION ONLY B.M. CH2M HILL Frederickson Cooper ARCHITECTS | | ENGINEER'S SEAL ORIGINAL SIGNED BY D.K. CUDDINGTON 2006/03/29 | EarthTech A Tyco International Ltd. Company | THE CITY OF WINNIPEG WATER AND WASTE DEPARTMENT ENGINEERING DIVISION WATER TREATMENT PLANT RESIDUALS HANDLING MECHANICAL AND ELECTRICAL PLUMBING RESIDUALS AREA THIRD FLOOR PLAN | CITY FILE NUMBER SHEET OF |
| | DESIGNED BY: JZ/SW CHECKED BY: DL DRAWN BY: JMcP APPROVED BY: AHL SCALE: 1:100 RELEASED FOR CONSTRUCTION BY: R. SOROKOWSKI DATE: 2005/08/02 DATE: 2006/03/29 | CONSULTANT DRAWING NO. WR-H0132 | CITY DRAWING NUMBER 1-0601R-A-H0132-001-020 | | | |