


SITE PLAN
SCALE: 1 : 750

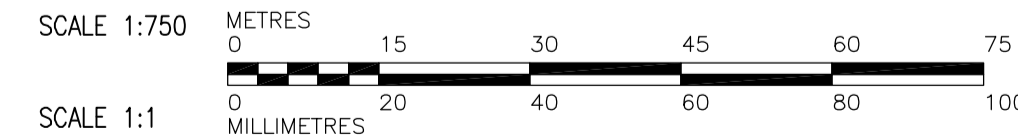

APEGM
Certificate of Authorization
Earth Tech Canada Inc.
No. 730

B.M. ELEV.			
00	ISSUED FOR TENDER	07/11/09	ERC
NO.	REVISIONS	DATE	BY

CH2MHILL
Frederickson Cooper ARCHITECTS

EarthTech
A Tyco International Ltd. Company

DESIGNED BY	BLM	CHECKED BY	PS
DRAWN BY	ERC	APPROVED BY	AHL
SCALE:	AS SHOWN	RELEASED FOR CONSTRUCTION BY:	R. SOROKOWSKI
DATE	2006/11/15	DATE	

ENGINEER'S SEAL
ORIGINAL SIGNED BY
P. STRYK
2007/11/09
CONSULTANT DRAWING NO.
WY-E0180

THE CITY OF WINNIPEG
WATER AND WASTE DEPARTMENT
ENGINEERING DIVISION

WATER TREATMENT PLANT
CONSTRUCTION OF ROADS AND LANDSCAPING

CITY FILE NUMBER	
SHEET	OF
CITY DRAWING NUMBER	1-0601Y-A-E0180-001-000

ELECTRICAL
SITE LIGHTING PLAN