


PLAN 1
 DEMOLITION
 SCALE 1:100
 0 1000 2000 3000 mm

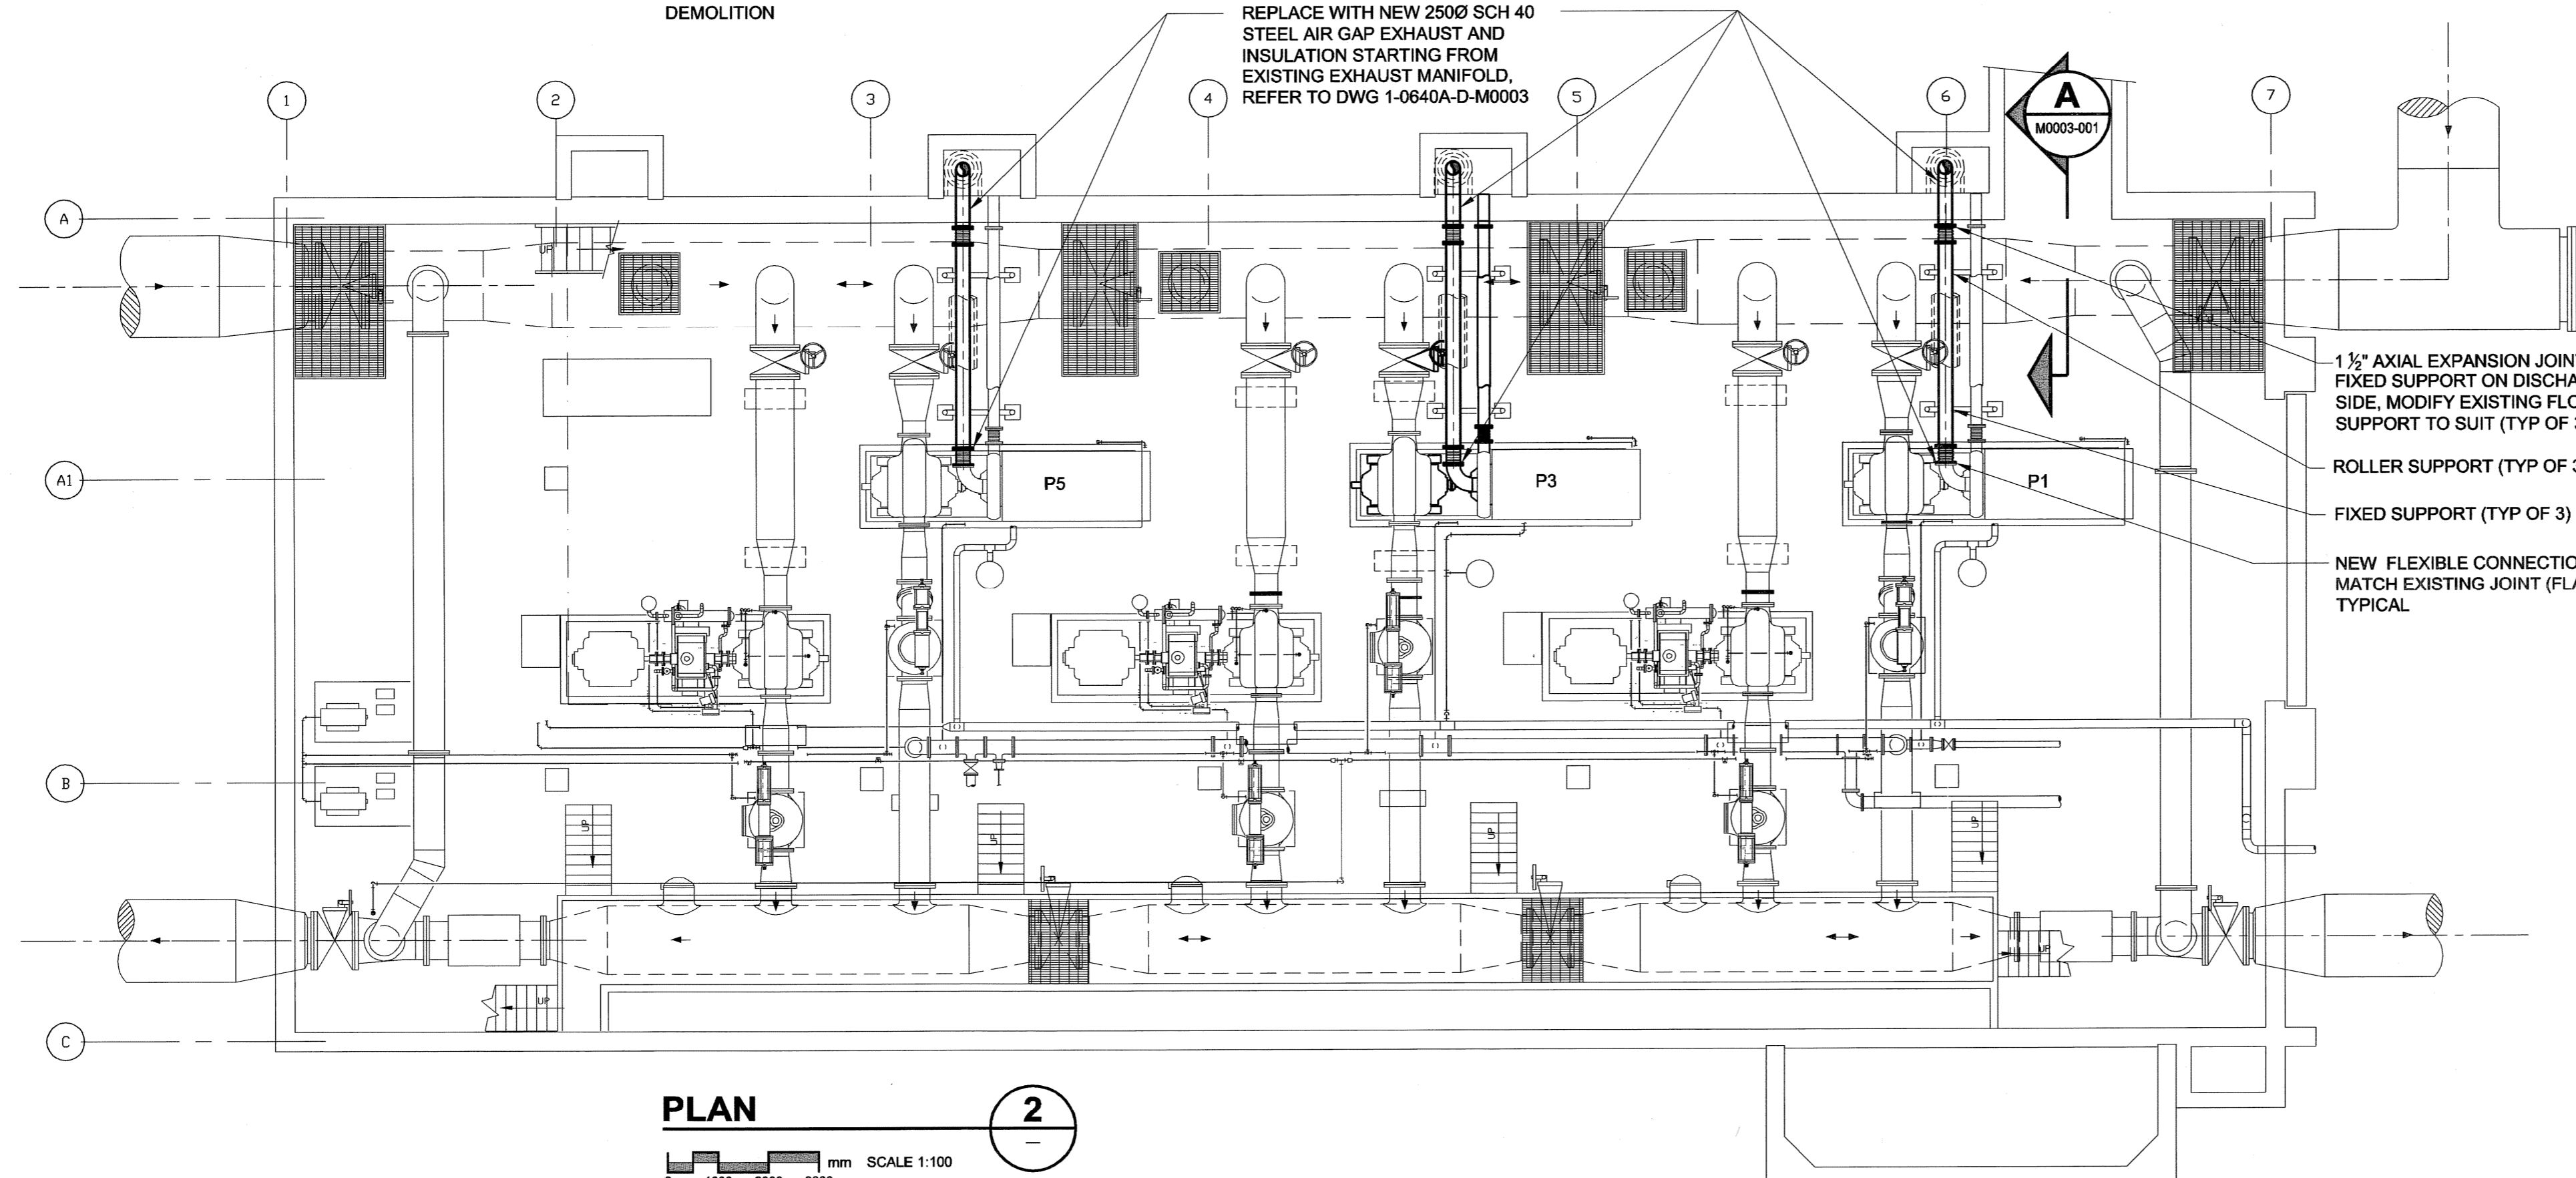

PLAN 2
 NEW CONSTRUCTION
 SCALE 1:100
 0 1000 2000 3000 mm

APEGM
 Certificate of Authorization
 UMA Engineering Ltd. (MB)
 No. 256 Date: Nov 25-08

UMA REVIEW
 DRN CHK DES ENG IDR

NO.	REVISIONS	DATE	BY
C	ISSUED FOR BID	08/11/21	RS
B	ISSUED FOR REVIEW	08/10/28	RS
A	ISSUED FOR REVIEW	08/09/29	RS
NO.	REVISIONS	YYMMDD	BY

DESIGNED BY	CC	CHECKED BY	
DRAWN BY	RS	APPROVED BY	
HOR. SCALE	AS NOTED	RELEASED FOR CONSTRUCTION	
VERT. SCALE	AS NOTED		
DATE		DATE	

© 2008 UMA Engineering Ltd. All Rights Reserved.
 This document is protected by copyright law and may not be used, reproduced or modified in any manner or for any purpose except with the written permission of UMA Engineering Ltd. or a party to which its copyright has been assigned. UMA accepts no responsibility, and denies any liability whatsoever, to any party that uses, reproduces, modifies, or relies on this document without UMA's express written consent.

PROFESSIONAL'S SEAL
 PROVINCE OF MANITOBA
 Nov 25-08
 C.A.D. COURCHAINE
 REGISTERED PROFESSIONAL ENGINEER
 CONSULTANT DRAWING NO.
 D265-199-00_04-M-0002_RX.dwg

THE CITY OF WINNIPEG
WATER AND WASTE DEPARTMENT

MCPHILLIPS PUMPING STATION
P1, 3, 5 EXHAUST REPLACEMENT
MECHANICAL - DEMOLITION/NEW CONSTRUCTION
PUMP/ENGINE LEVEL FLOOR PLAN

SHEET 1 OF 1
 CITY DRAWING NUMBER
 1-0640M-M0002-001
 REV C