

 

NOTES:

- DISCONNECT EXISTING BREATHING AIR COMPRESSORS AND ASSOCIATED CONTROLS UPON COMMISSIONING OF THE NEW BREATHING AIR SYSTEM.
- WIRE AND CONNECT 30HP COMPRESSOR PACKAGES AC-1 AND AC-2, 460V-3PH. INSTALL, WIRE AND CONNECT 600V-460V TRANSFORMERS SUPPLIED BY COMPRESSOR VENDOR AND VFD CONTROLLER. FEED EACH COMPRESSOR FROM A NEW MATCHING 50A-3P CIRCUIT BREAKER IN PANEL LP-RB WITH 3/8 TECK. WIRE DRAIN VALVES TO A NEW MATCHING 15A-1P CIRCUIT BREAKER IN PANEL PBL.
- WIRE AND CONNECT DRYER/BREATHING AIR PACKAGE TO A NEW MATCHING 15A-1P CIRCUIT BREAKER IN PANEL PBL WITH 2#12 TECK.
- BREATHING AIR SYSTEM REMOTE ALARM PANEL. WIRE TO A NEW MATCHING 15A-1P CIRCUIT BREAKER IN PANEL PBL AND ASSOCIATED MECHANICAL SYSTEM CONTROLLERS AND REMOTE ALARMS.
- EXISTING VISUAL AND AUDIBLE ALARMS. TIE TO BREATHING AIR CONTROL PANEL. PROVIDE MATCHING SIGNALS. ALL WIRING WITHIN PAINT BOOTHS TO BE SUITABLE FOR CLASS 1 ZONE 1 INSTALLATION.

SYMBOL LEGEND

- ELECTRIC MOTOR. REFER TO MECHANICAL DRAWINGS FOR EXACT LOCATION.
- DISCONNECT SWITCH BY ELECTRICAL CONTRACTOR.
- PANELBOARD.
- JUNCTION BOX.
- ALARM HORN.
- ALARM STROBE LIGHT.

1 PARTIAL MAIN FLOOR PLAN - ELECTRICAL LAYOUT
1/8" = 1'-0"

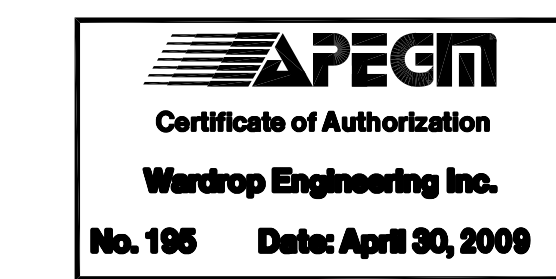

NO.	DESCRIPTION	DATE	ISSUED BY
00	ISSUED FOR TENDER	08.10.09	L.K.

REVISIONS/ISSUE
THE CONTENT OF THIS DOCUMENT IS NOT INTENDED FOR THE USE OF, NOR IS IT INTENDED TO BE RELIED UPON BY ANY PERSON, FIRM OR CORPORATION, OTHER THAN THE CLIENT AND WARDROP ENGINEERING INC. WARDROP ENGINEERING OWNS ANY LIABILITY WHATSOEVER TO OTHER PARTIES FOR DAMAGES OR INJURY SUFFERED BY SUCH THIRD PARTY ARISING FROM USE OF THIS DOCUMENT BY THEM, WITHOUT THE EXPRESS PRIOR WRITTEN AUTHORITY OF WARDROP ENGINEERING AND OUR CLIENT. THIS DOCUMENT IS SUBJECT TO FURTHER RESTRICTIONS IMPOSED BY THE CONTRACT BETWEEN THE CLIENT AND WARDROP ENGINEERING INC. AND THESE PARTIES' PERMISSION MUST BE SOUGHT REGARDING THIS DOCUMENT IN ALL OTHER CIRCUMSTANCES.

CLIENT
**CITY OF WINNIPEG
 TRANSIT DEPARTMENT**

WARDROP | Engineering Inc.

PROJECT NAME
**WINNIPEG TRANSIT - OSBORNE STREET GARAGE
 PAINT BOOTH BREATHING AIR SYSTEM UPGRADE**

DRAWING DESCRIPTION
**PARTIAL MAIN FLOOR PLAN
 ELECTRICAL LAYOUT**

ISSUED FOR INFORMATION ONLY	DESIGNED BY: L.K.	DRAWN BY: T.S.	CHECKED BY: L.K.
	APPROVED BY: AR		
	SCALE: AS NOTED	DATE: 08.04.08	
	DRAWING NO. 0829720102-DWG-E0001	REV. 00	