




NOTES :

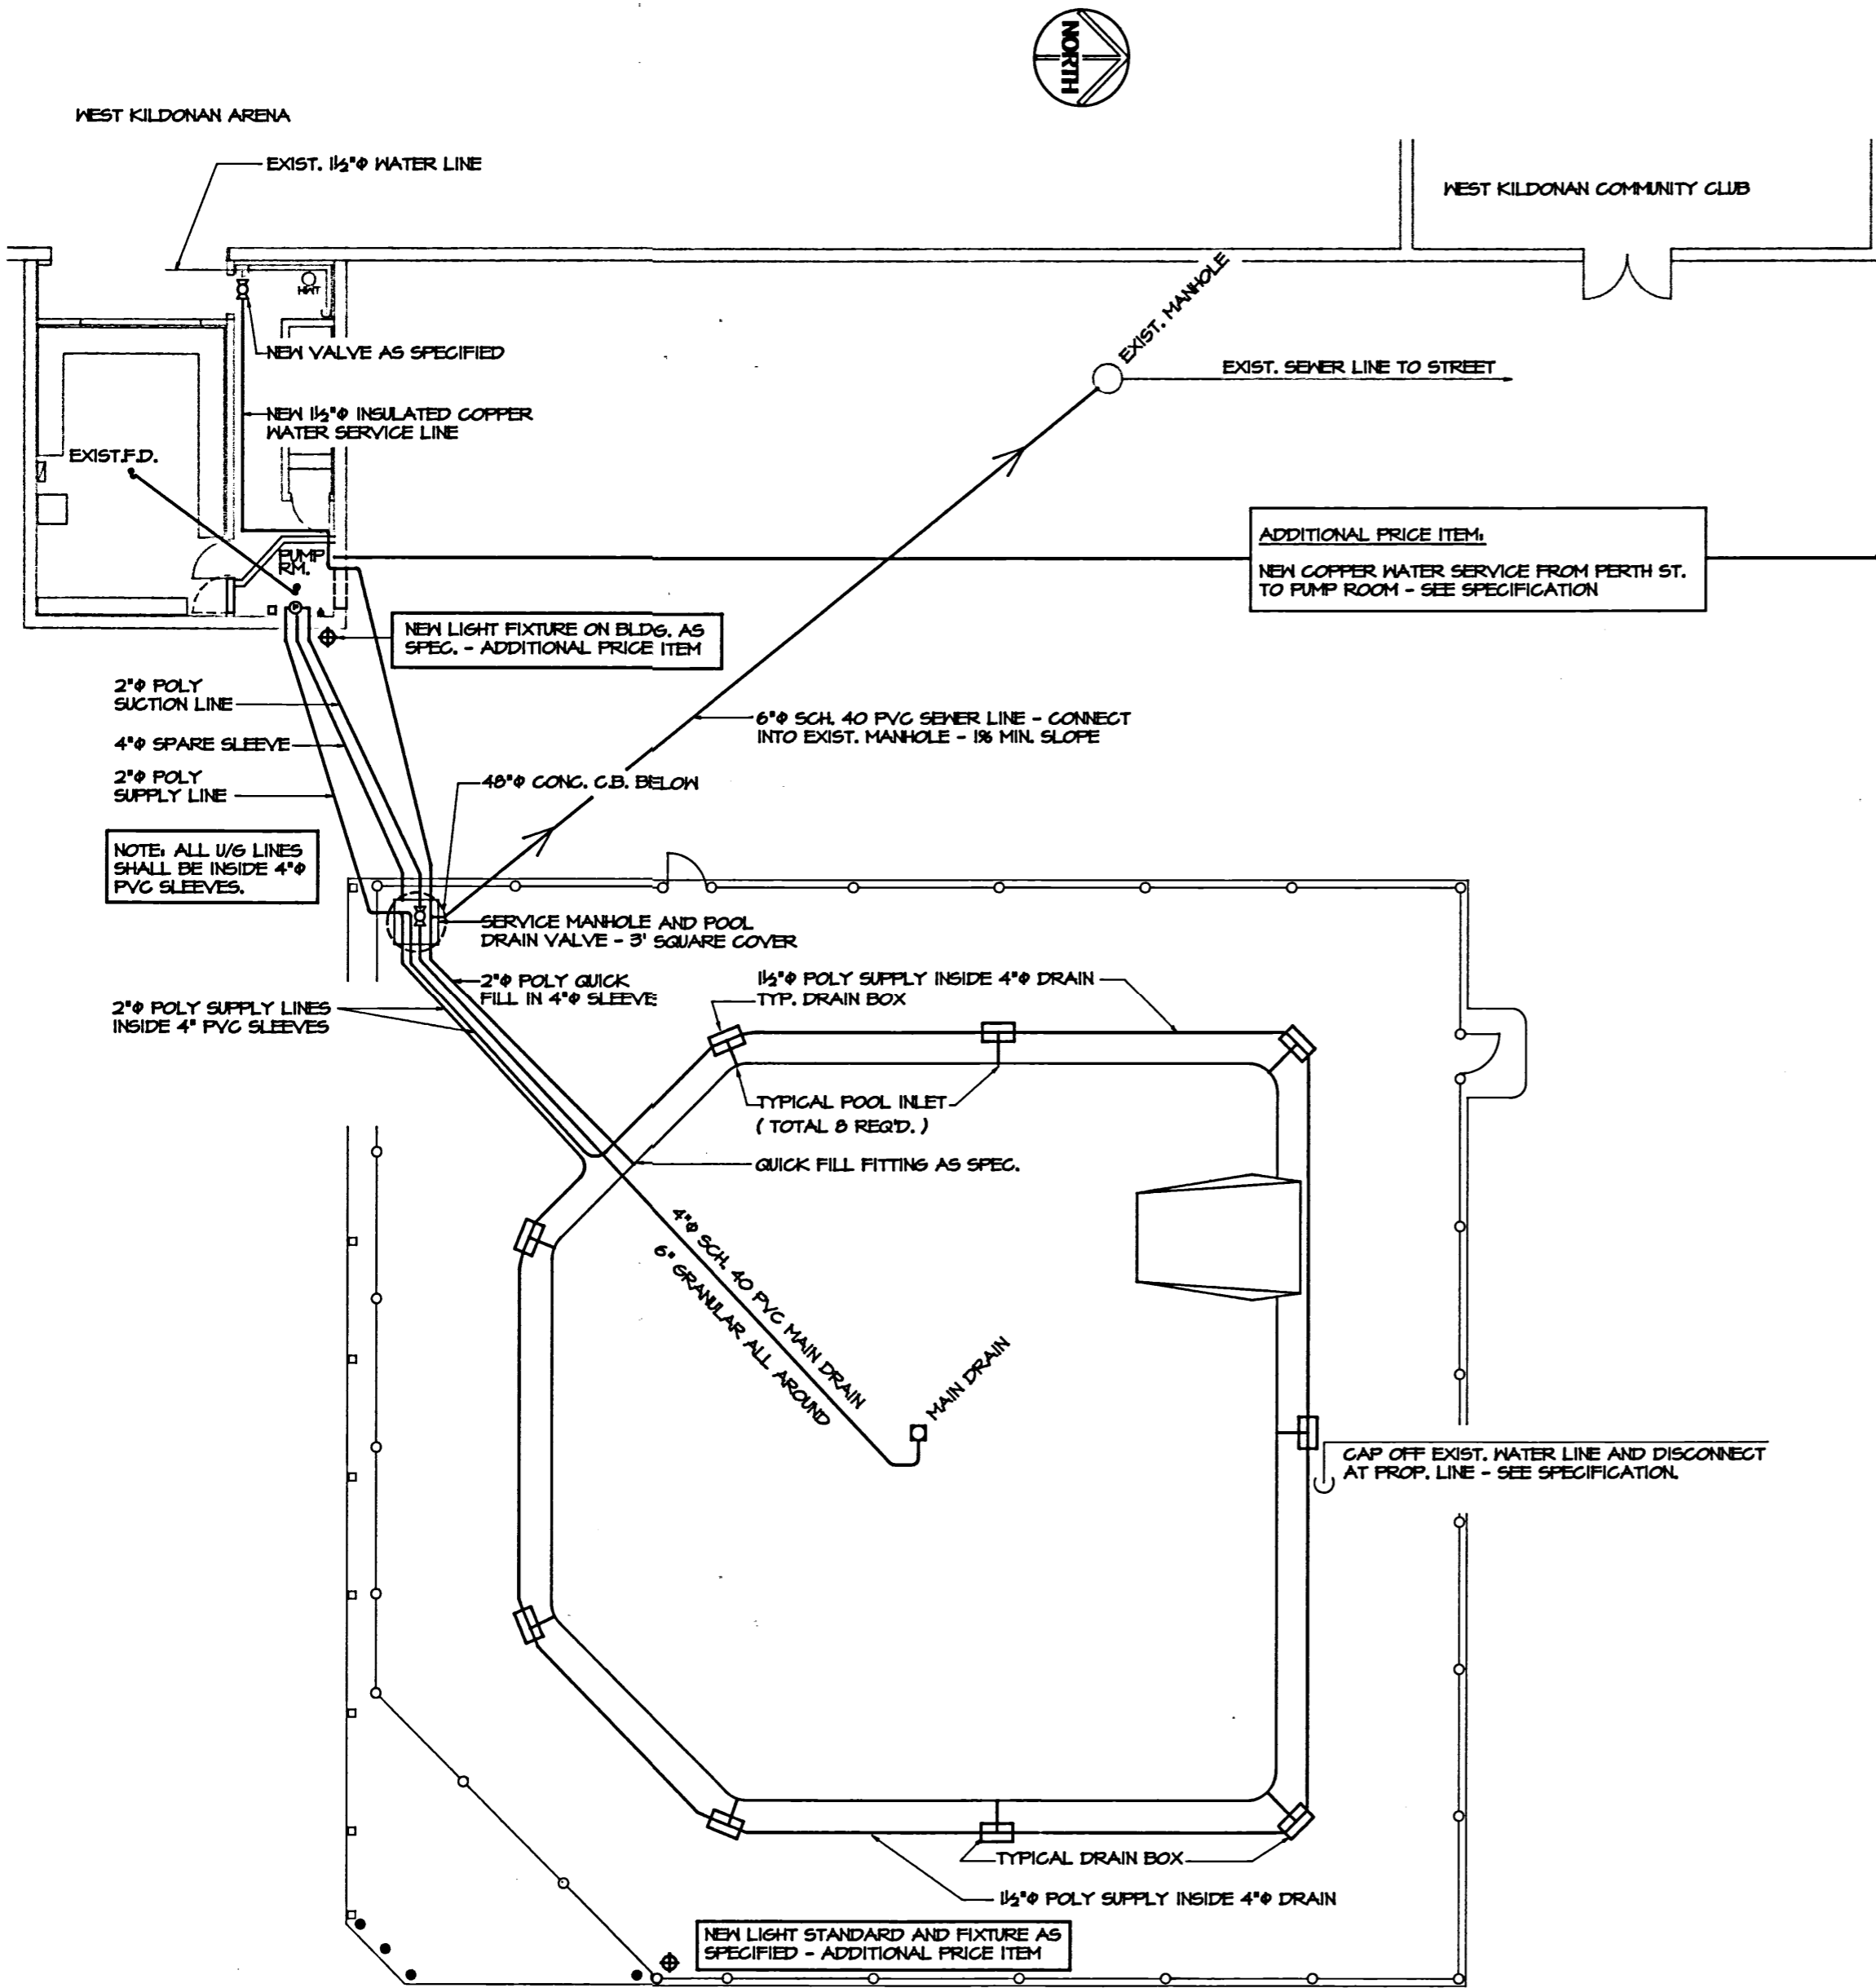


PIPING LAYOUT
SCALE: 3/32"=1'0"

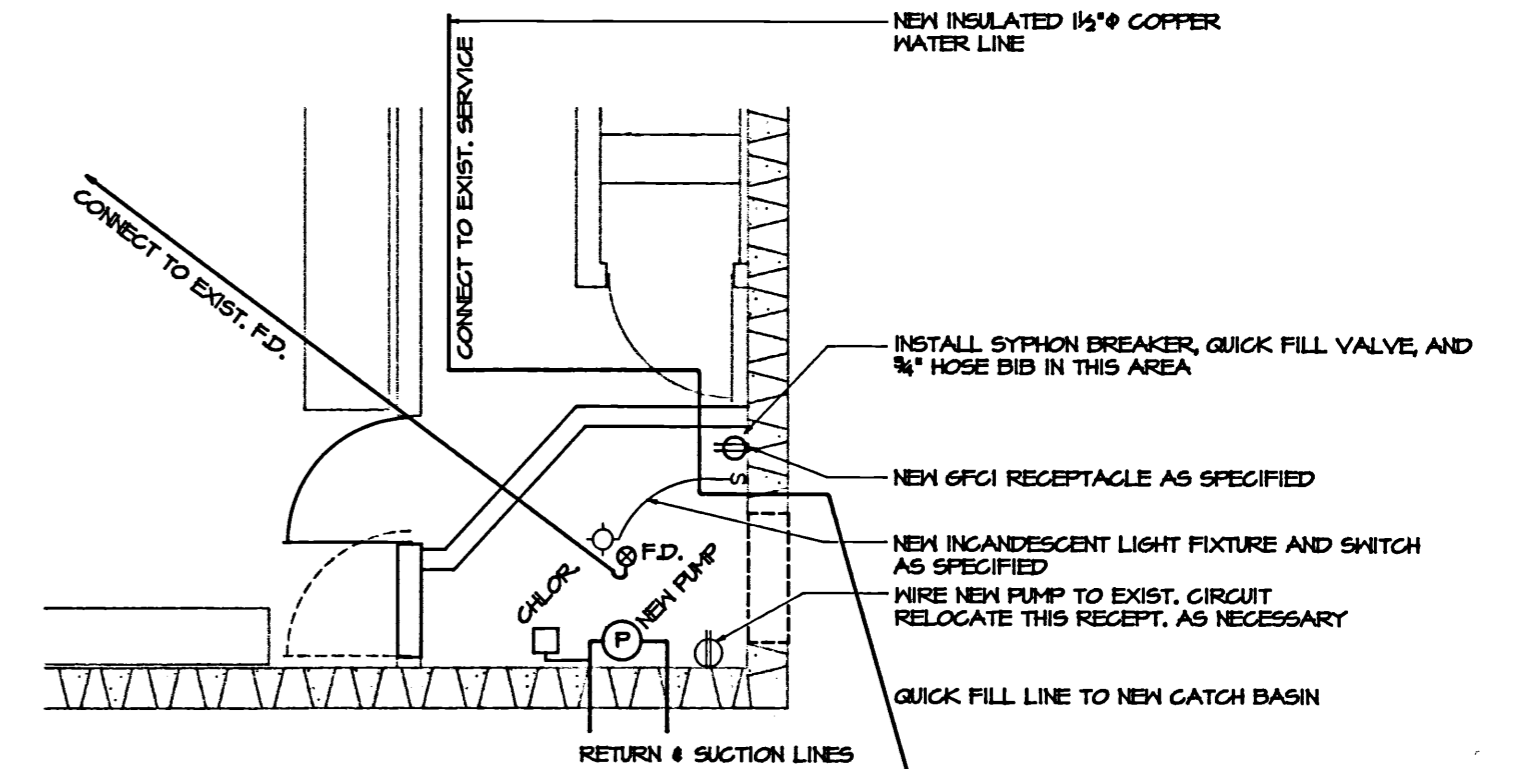

PUMP ROOM LAYOUT
SCALE: 1/4"=1'0"

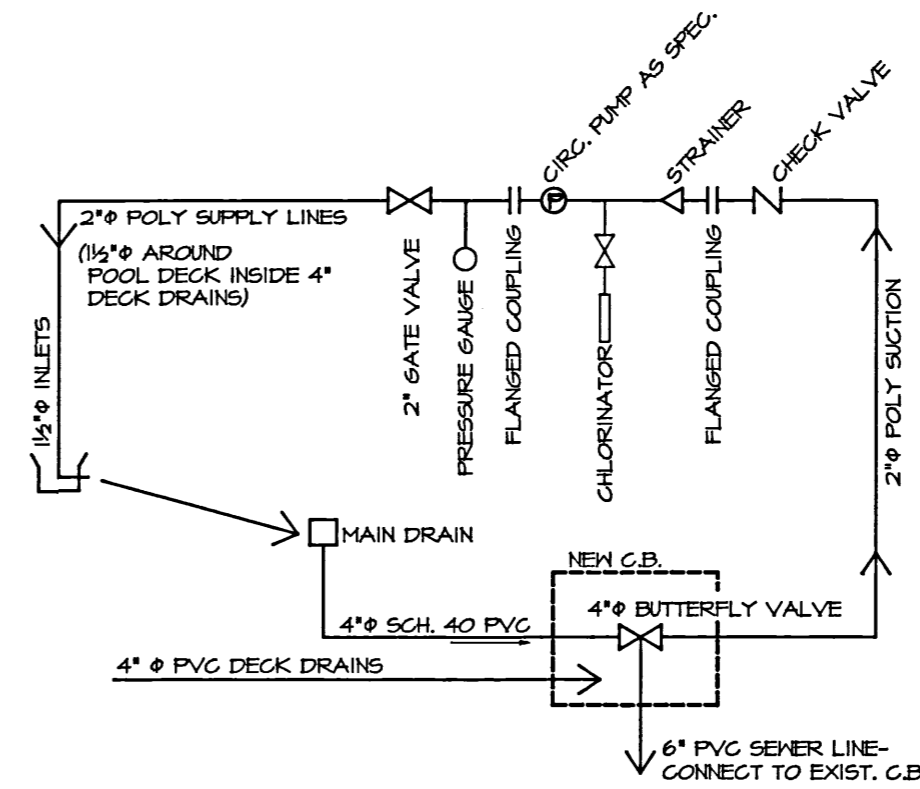


POOL SYSTEM SCHEMATIC

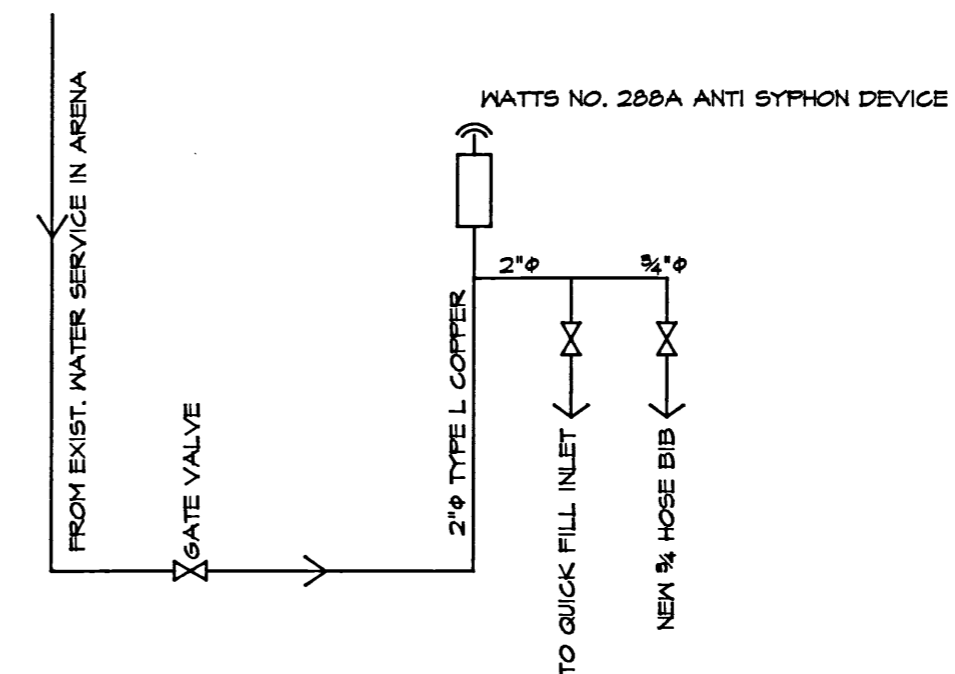

SUPPLY SCHEMATIC

NO.	REVISION/DESCRIPTION	BY	DATE
SEALS			

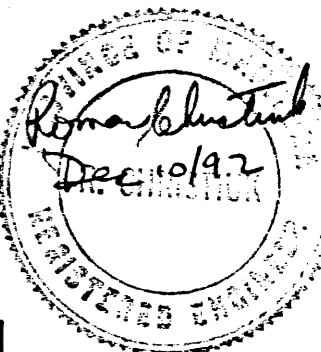

DRAWN BY ROH	CHECKED BY	APPROVED
DATE SEPT. 92	USER APPROVAL	

THE CITY OF WINNIPEG
CIVIC PROPERTIES DEPARTMENT
400-180 KING ST. R3B 3G8

PROJECT
**WEST KILDONAN C.C.
WADING POOL
346 PERTH AVE.**

SHEET TITLE

MECHANICAL

SCALE AS SHOWN	PROJECT NO. 42-302	SHEET NO. 3 0348PE03
-------------------	-----------------------	-----------------------------------