


GENERAL NOTES

- A. ALL ABANDONED EQUIPMENT AND SERVICES WITHIN AREA OF WORK SHALL BE REMOVED.
- B. THIS BUILDING MAY CONTAIN ASBESTOS. REFER TO FRONT END SPECIFICATIONS FOR FURTHER INFORMATION.
- C. REFER TO ROOF DETAILS FOR ALL NEW AND CAPPED OPENINGS.

KEY NOTES @

- 1. PROVIDE NEW GAS FIRED INFRARED HEATER, INSTALL AS HIGH AS POSSIBLE BUT AT LEAST 5' ABOVE HEIGHT OF BUS. PROVIDE MAXIMUM ALLOWANCE STACKING HEIGHT SIGNS AND OTHER SIGNS REQUIRED BY MANUFACTURER. PROVIDE LOWER RADIANT SHIELD TO BURNER, INSTALL IN ACCORDANCE WITH MANUFACTURER REQUIREMENTS.
- 2. INSTALL FLUE VENT IN ACCORDANCE WITH MANUFACTURER REQUIREMENTS.
- 3. PROVIDE NEW THERMOSTAT AND WIRE TO BLACK BULB SENSOR MOUNTED BETWEEN UNITS. INSTALL IN ACCORDANCE WITH MANUFACTURER REQUIREMENTS.
- 4. COMBUSTION AIR INTAKE THROUGH ROOF. PROVIDE WEATHER TIGHT SEAL IN ACCORDANCE WITH ROOF DETAIL. CONTRACTOR TO CONFIRM THE EXACT LOCATION ON SITE. REFER TO DETAIL 1M3.1.
- 5. RV VENT THROUGH ROOF. PROVIDE WEATHER TIGHT SEAL IN ACCORDANCE WITH ROOF DETAIL. CONTRACTOR TO CONFIRM THE EXACT LOCATION ON SITE.
- 6. PROVIDE NEW RAPID ROLL DOOR. CONTRACTOR TO SECURE THE NEW DOOR MOUNTING ANGLES TO THE EXISTING CONCRETE STRUCTURE USING 1/2" DIAMETER X 4" EMBROIDMENT HLT HAS-R ROD AND HLT HIT-HY 200 GROUT SPACED AS PER THE MOUNTING ANGLE BOLTING HOLES.
- 7. ELECTRICAL SUBCONTRACTOR TO PROVIDE IN-FLOOR VEHICLE SENSING LOOP TO NEW RAPID ROLL DOOR. PATCH AND REPAIR CONCRETE TO SUIT.
- 8. PROVIDE NEW RED/GREEN TRAFFIC LIGHTS FOR EACH NEW OVERHEAD DOOR. COORDINATE FINAL PLACEMENT AND ANGLE ON SITE WITH TRANSIT.

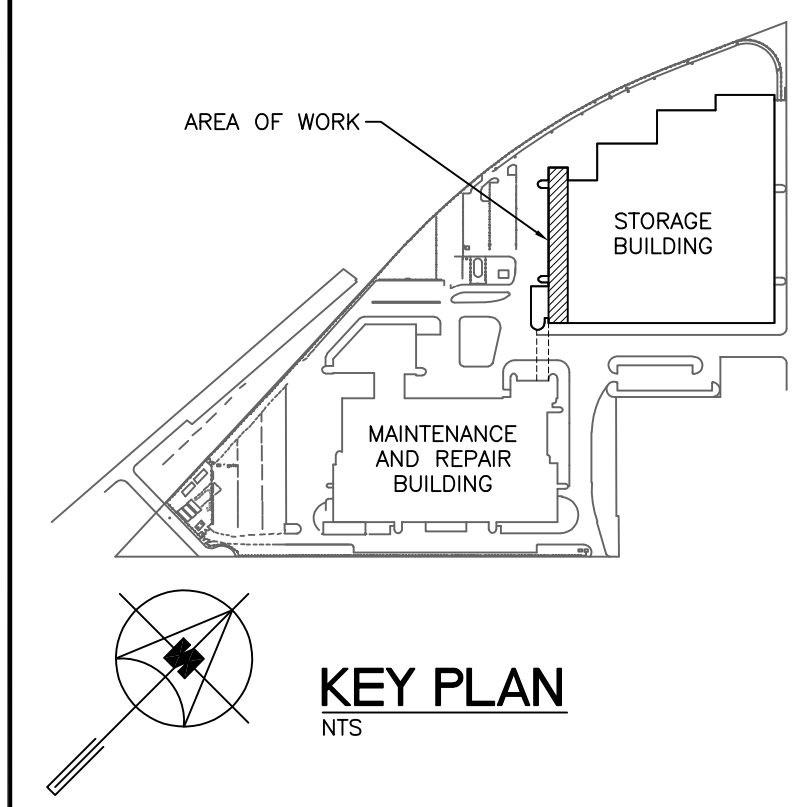

| | | | |
|-----|-------------------------|----|----------|
| 5 | | | |
| 4 | | | |
| 3 | | | |
| 2 | | | |
| 1 | | | |
| 0 | ISSUED FOR CONSTRUCTION | JH | 16/04/19 |
| NO. | Description | BY | DD/MM/YY |



Project Title
**CITY OF WINNIPEG FORT ROUGE
 TRANSIT BASE - RAPID ROLL DOORS
 AND RADIANT HEATERS REPLACEMENT**

WINNIPEG MANITOBA
**MAIN FLOOR AND ROOF PLAN -
 SERVICE BAY -
 NEW CONSTRUCTION -
 MECHANICAL**

| | | |
|----------------------|------------------------|--------------------------|
| Drawn By XZ/IE | Checked By XZ | Approved By JH |
| Scale AS SHOWN | Date APRIL 2019 | Project No. 19-028-01 |
| Revision Number 0 | Drawing Number M2.1 | Sheet Order 2 OF 4 |

1 MAIN FLOOR PLAN - NEW CONSTRUCTION - PLUMBING
 SCALE: 1/16" = 1'-0"

2 ROOF PLAN - NEW CONSTRUCTION - PLUMBING
 SCALE: 1/16" = 1'-0"