



PLAN
1:100


KEY PLAN
NTS

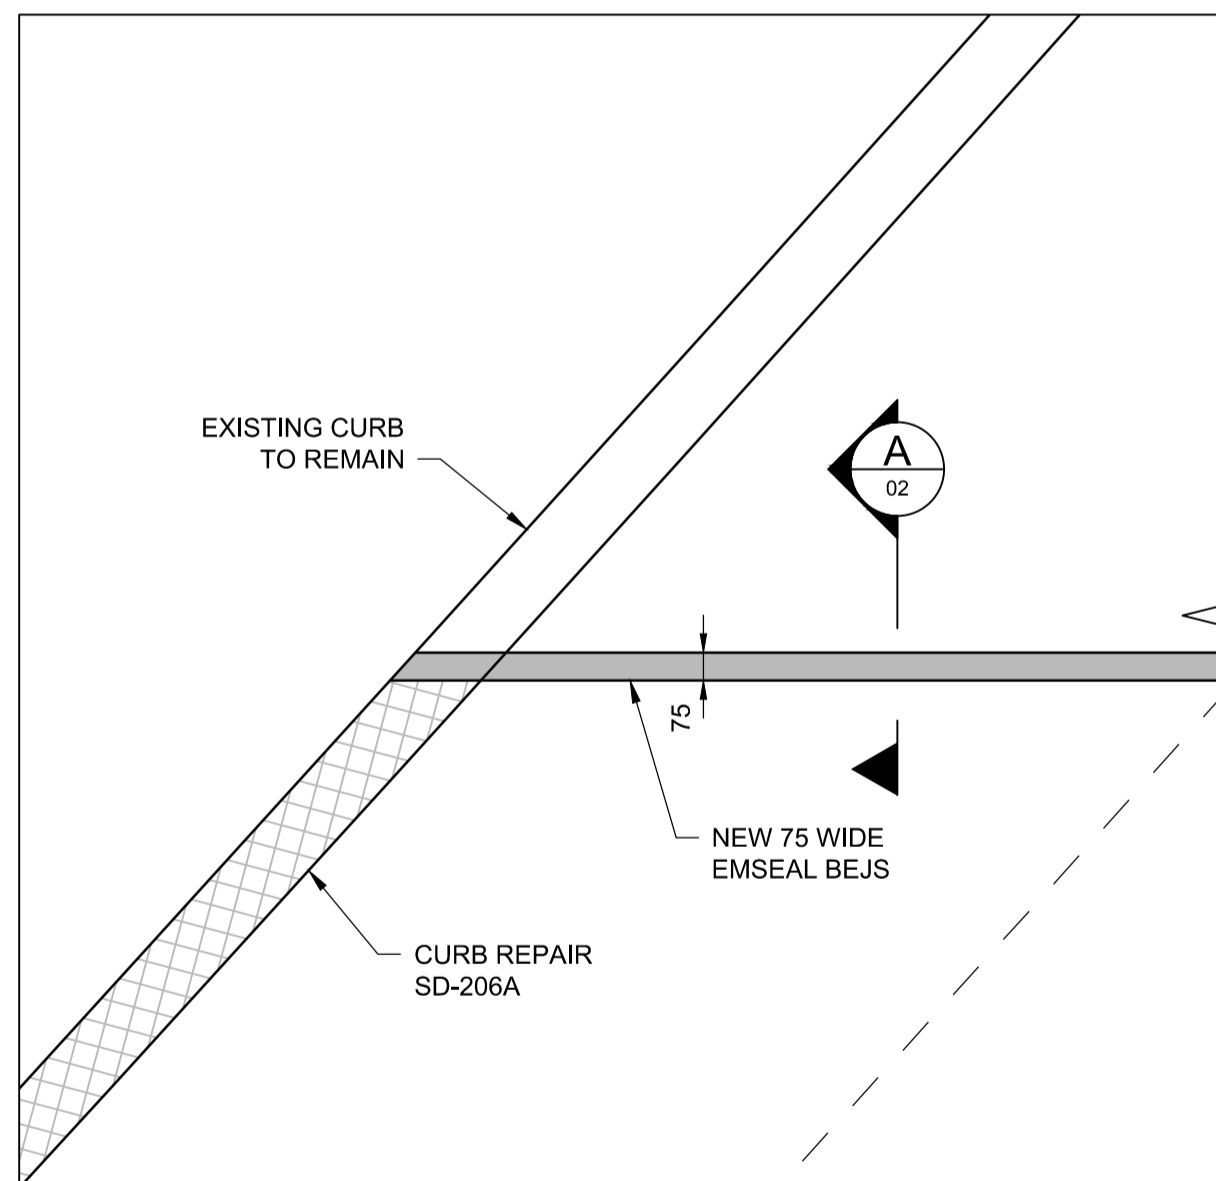


1 DETAIL
1:20

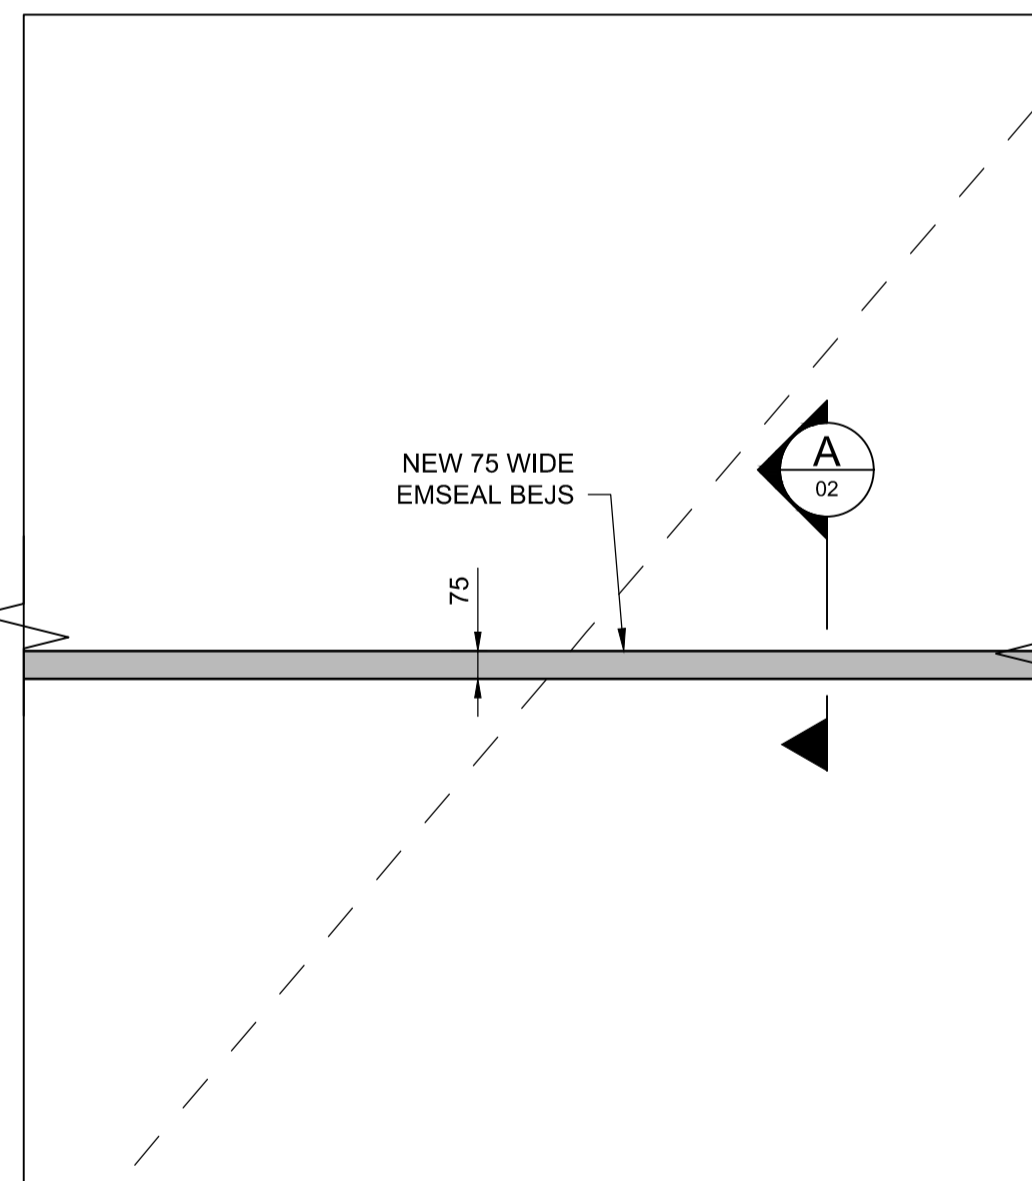

2 DETAIL
1:20

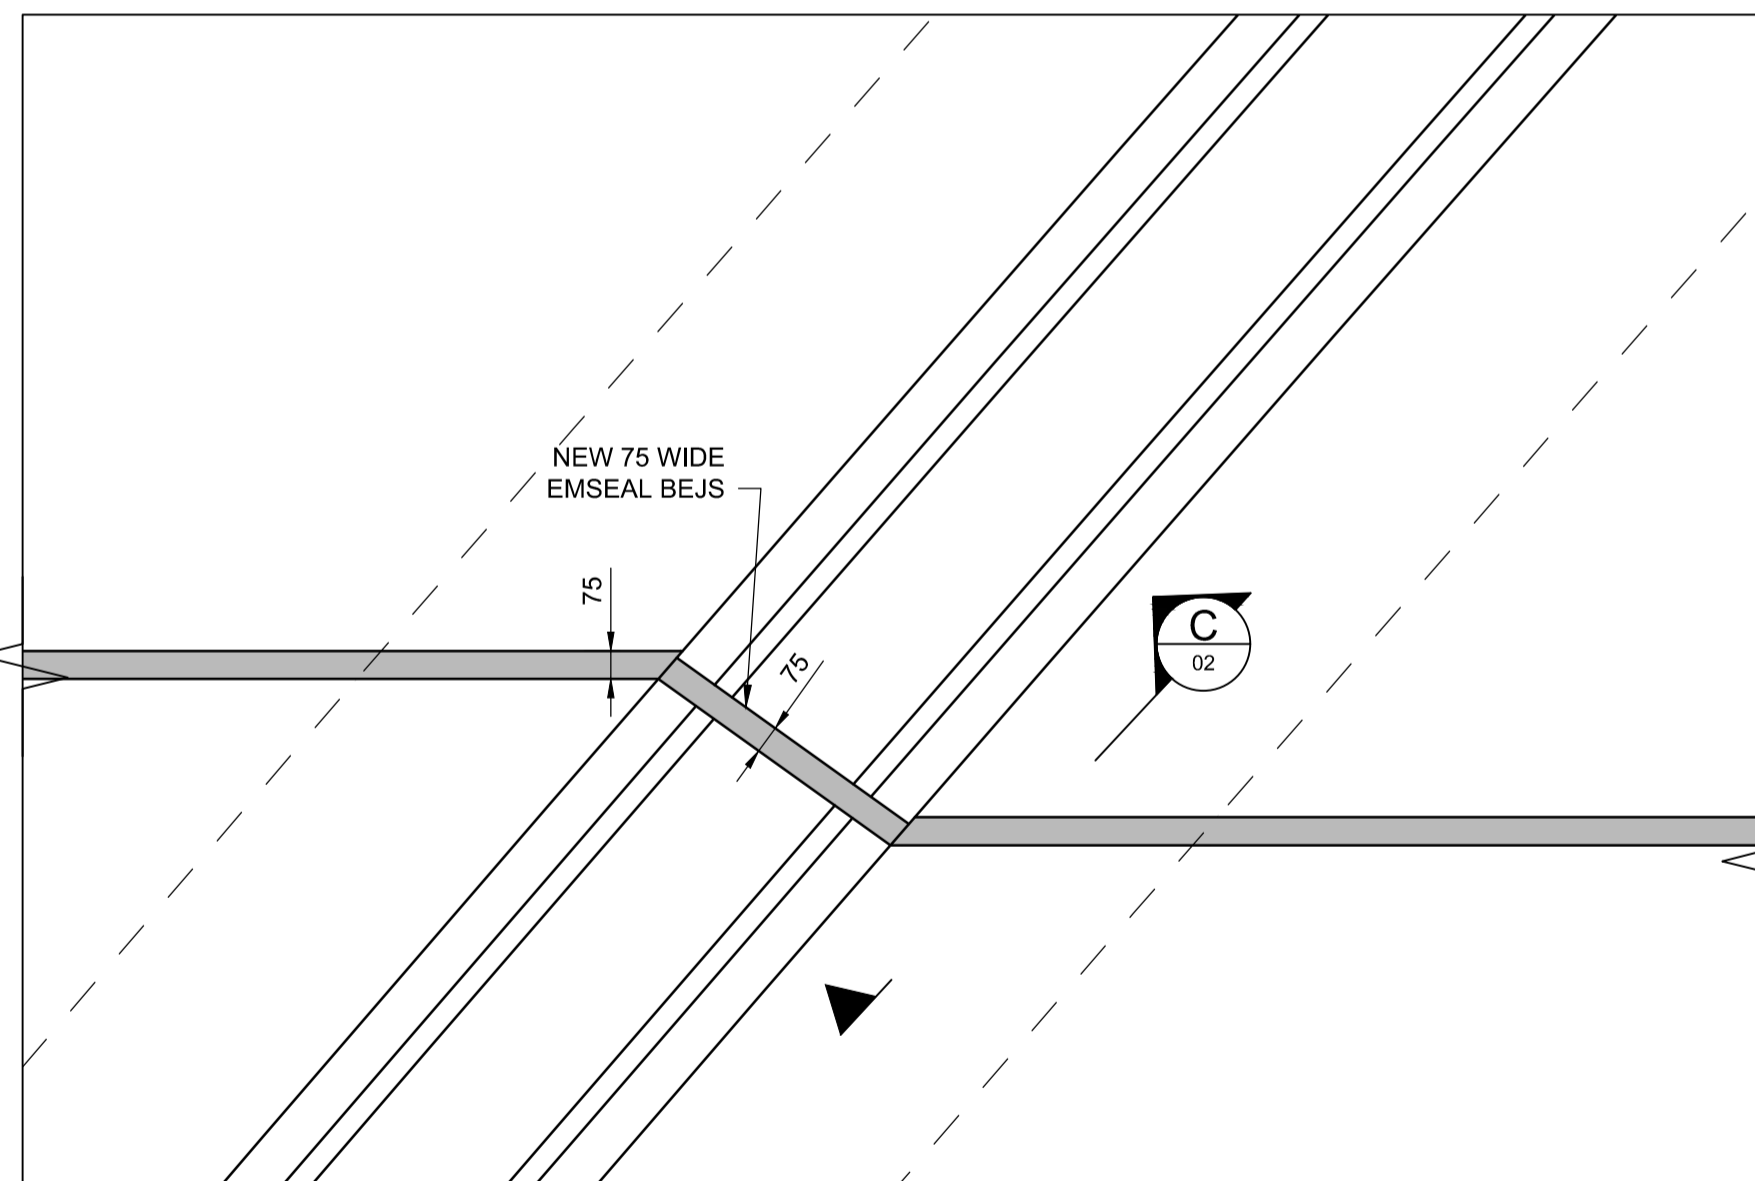

3 DETAIL
1:20

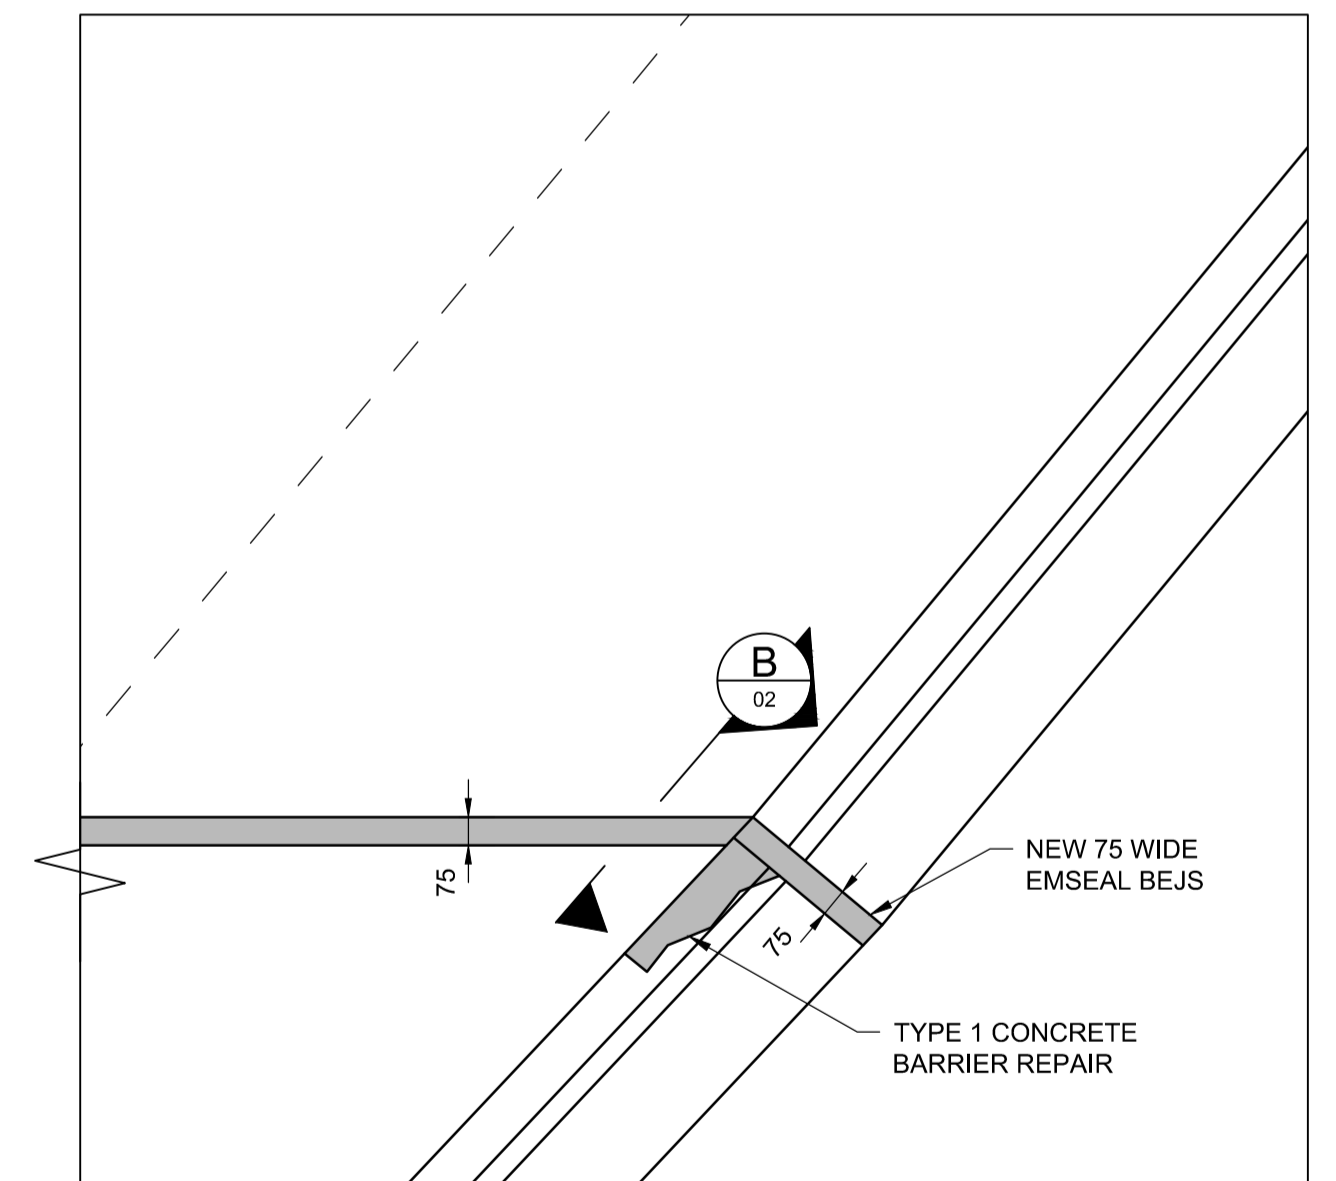


4 DETAIL
1:20

METRIC

WHOLE NUMBERS INDICATE MILLIMETRES
DECIMALIZED NUMBERS INDICATE METRES



B.M. ELEV.	DESIGNED BY	KB
	DRAWN BY	MDG
	CHECKED BY	DRA
	APPROVED BY	RJT
	HOR. SCALE	-
	VERTICAL	-
	DATE	2019/04/17
1	ISSUED FOR CONSTRUCTION	19/04/17 KB
NO.	REVISIONS	DATE BY

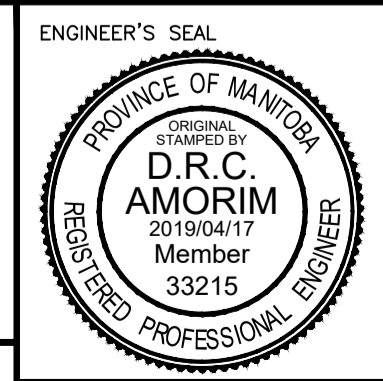

THE CITY OF WINNIPEG
PUBLIC WORKS DEPARTMENT

2019 BRIDGE MAINTENANCE
B110 PROVENCHER BRIDGE

Winnipeg

CONSULTANT PROJECT NUMBER
19-9109

CITY DRAWING NUMBER
B110-19-01

SHEET 01 OF 07

CONSULTANT DRAWING NUMBER
--

SITE PLAN