


1 PARTIAL SINGLE LINE DIAGRAM
 E-102 N.T.S.

- NOTES:
 1. UTILIZE EXISTING 25A-3P SPARE CIRCUIT BREAKERS
 IN PANEL PP-1A.

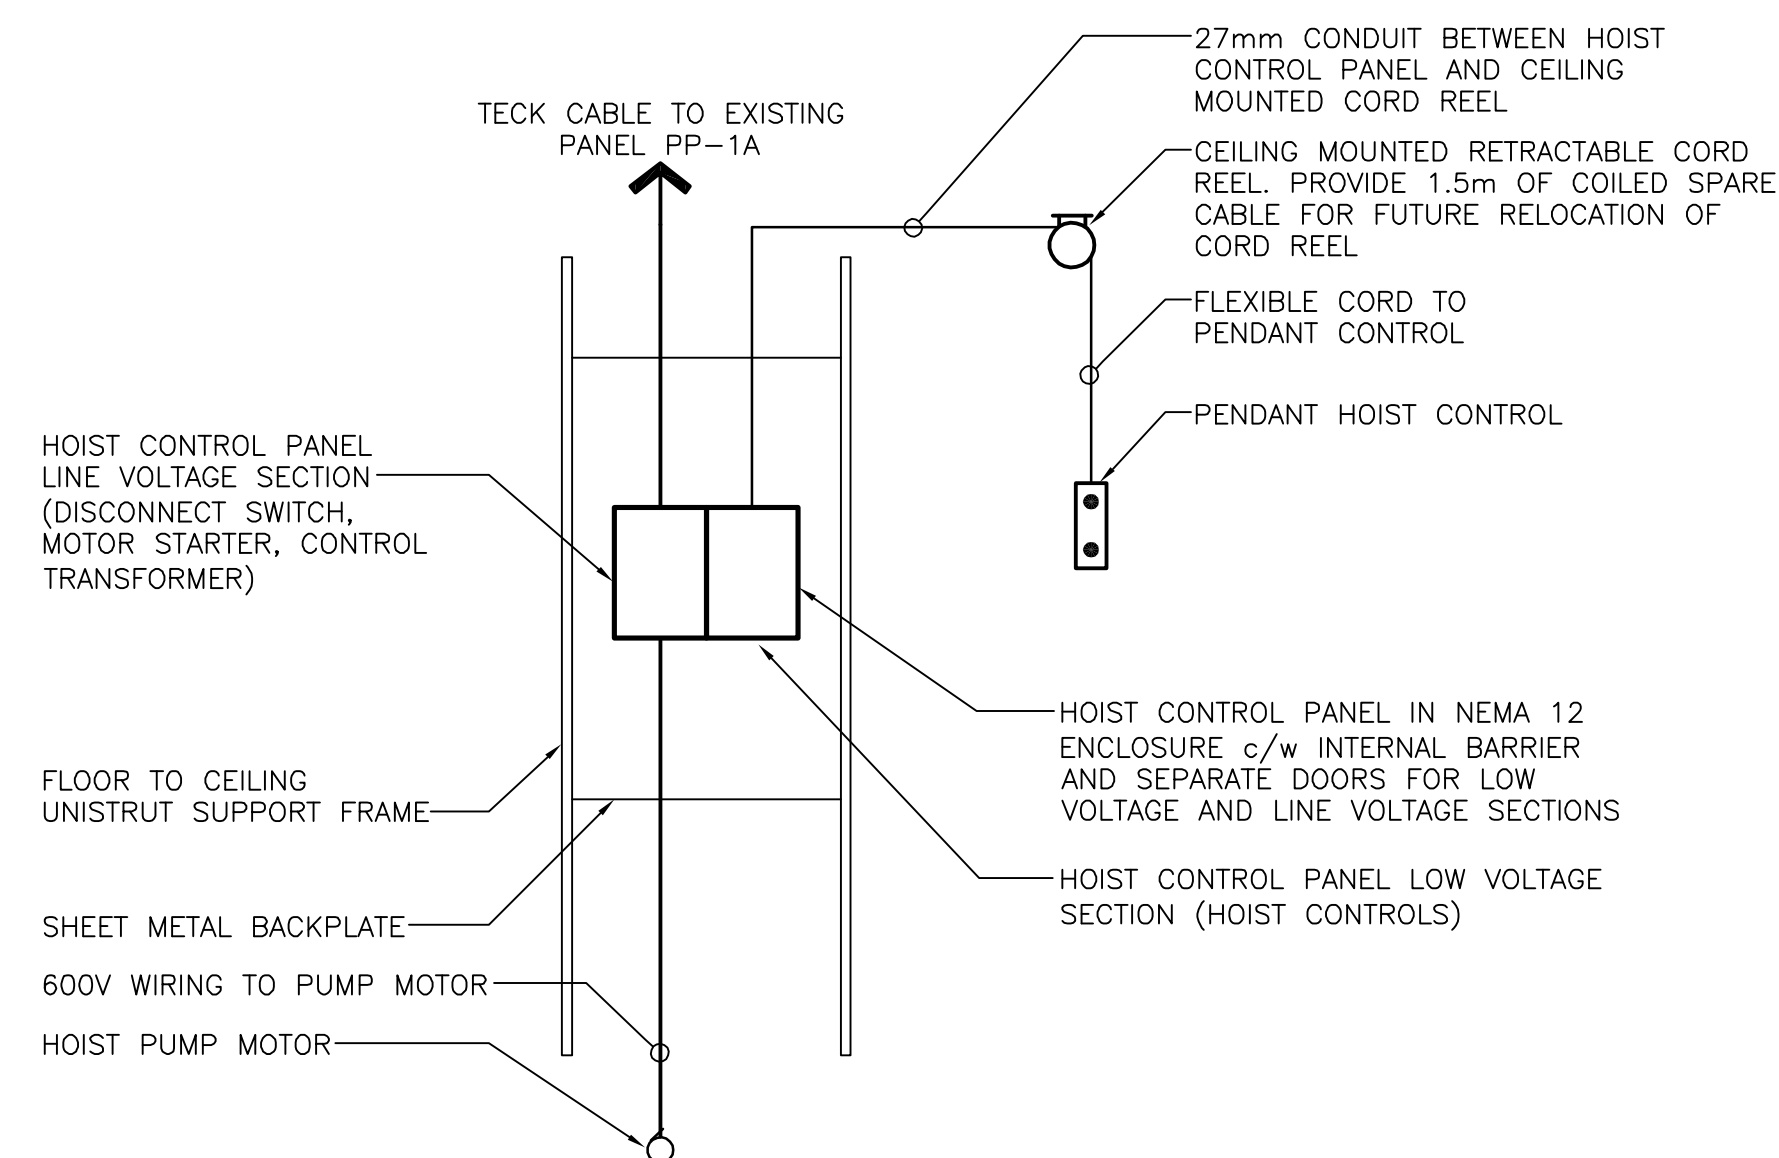

2 MOTOR CONTROL DETAIL
 E-102 N.T.S.

SYMBOL LEGEND

	DISCONNECT SWITCH
	MAGNETIC STARTER
	HOIST PUMP MOTOR

Legend

Notes

Revision	By	Appd.	YY.MM.DD
5			
4			
3			
2			
1			
E			
D			
C	ISSUED FOR CONSTRUCTION	HPCC	LK 2021.07.13
B	ISSUED FOR TENDER	HPCC	LK 2021.06.23
A	ISSUED FOR 90% REVIEW	HPCC	LK 2021.01.15
Issued			
File Name:	e-102		21.07.12
	Dwn.	Chkd.	Dgn.

Permit-Seal

**ENGINEERS
 GEOSCIENTISTS
 MANITOBA**
 Certificate of Authorization
 Stantec Consulting Ltd.
 No. 1301



Client/Project
 WINNIPEG TRANSIT
 GARAGE BUILDING
 HOIST REPLACEMENT PROGRAM
 PHASE 2 - HOISTS 8 - 12
 421 Osborne Street, Winnipeg Manitoba

Title
 ELECTRICAL
 PARTIAL SINGLE LINE DIAGRAM
 & MOTOR CONTROL DETAIL

Project No. 115420037	Scale N.T.S.
Drawing No.	Sheet Revision