

Revision	By	Appd.	YY.MM.DD
E	BH	BH	21.07.13
D	BH	BH	21.06.23
C	BH	BH	21.01.15
B	BH	BH	20.12.16
A	BH	BH	20.11.13
Issued	By	Appd.	YY.MM.DD
File Name:	20037_mech_plumbing_jfc		21.07.12
Permit-Seal	Dwn.	Chkd.	Dsgn.


Permit-Seal

ENGINEERS
 GEOSCIENTISTS
 MANITOBA
 Certificate of Authorization
 Stantec Consulting Ltd.
 No. 1301


Client/Project
 WINNIPEG TRANSIT
 GARAGE BUILDING
 HOIST REPLACEMENT PROGRAM
 PHASE 2 - HOISTS 8 - 12
 421 Osborne Street, Winnipeg Manitoba

Title
 MAIN FLOOR SANITARY DRAINAGE AND
 VENTILATION CONSTRUCTION PLAN


Project No.	Scale	
115420037	1:100	
Drawing No.	Sheet	Revision

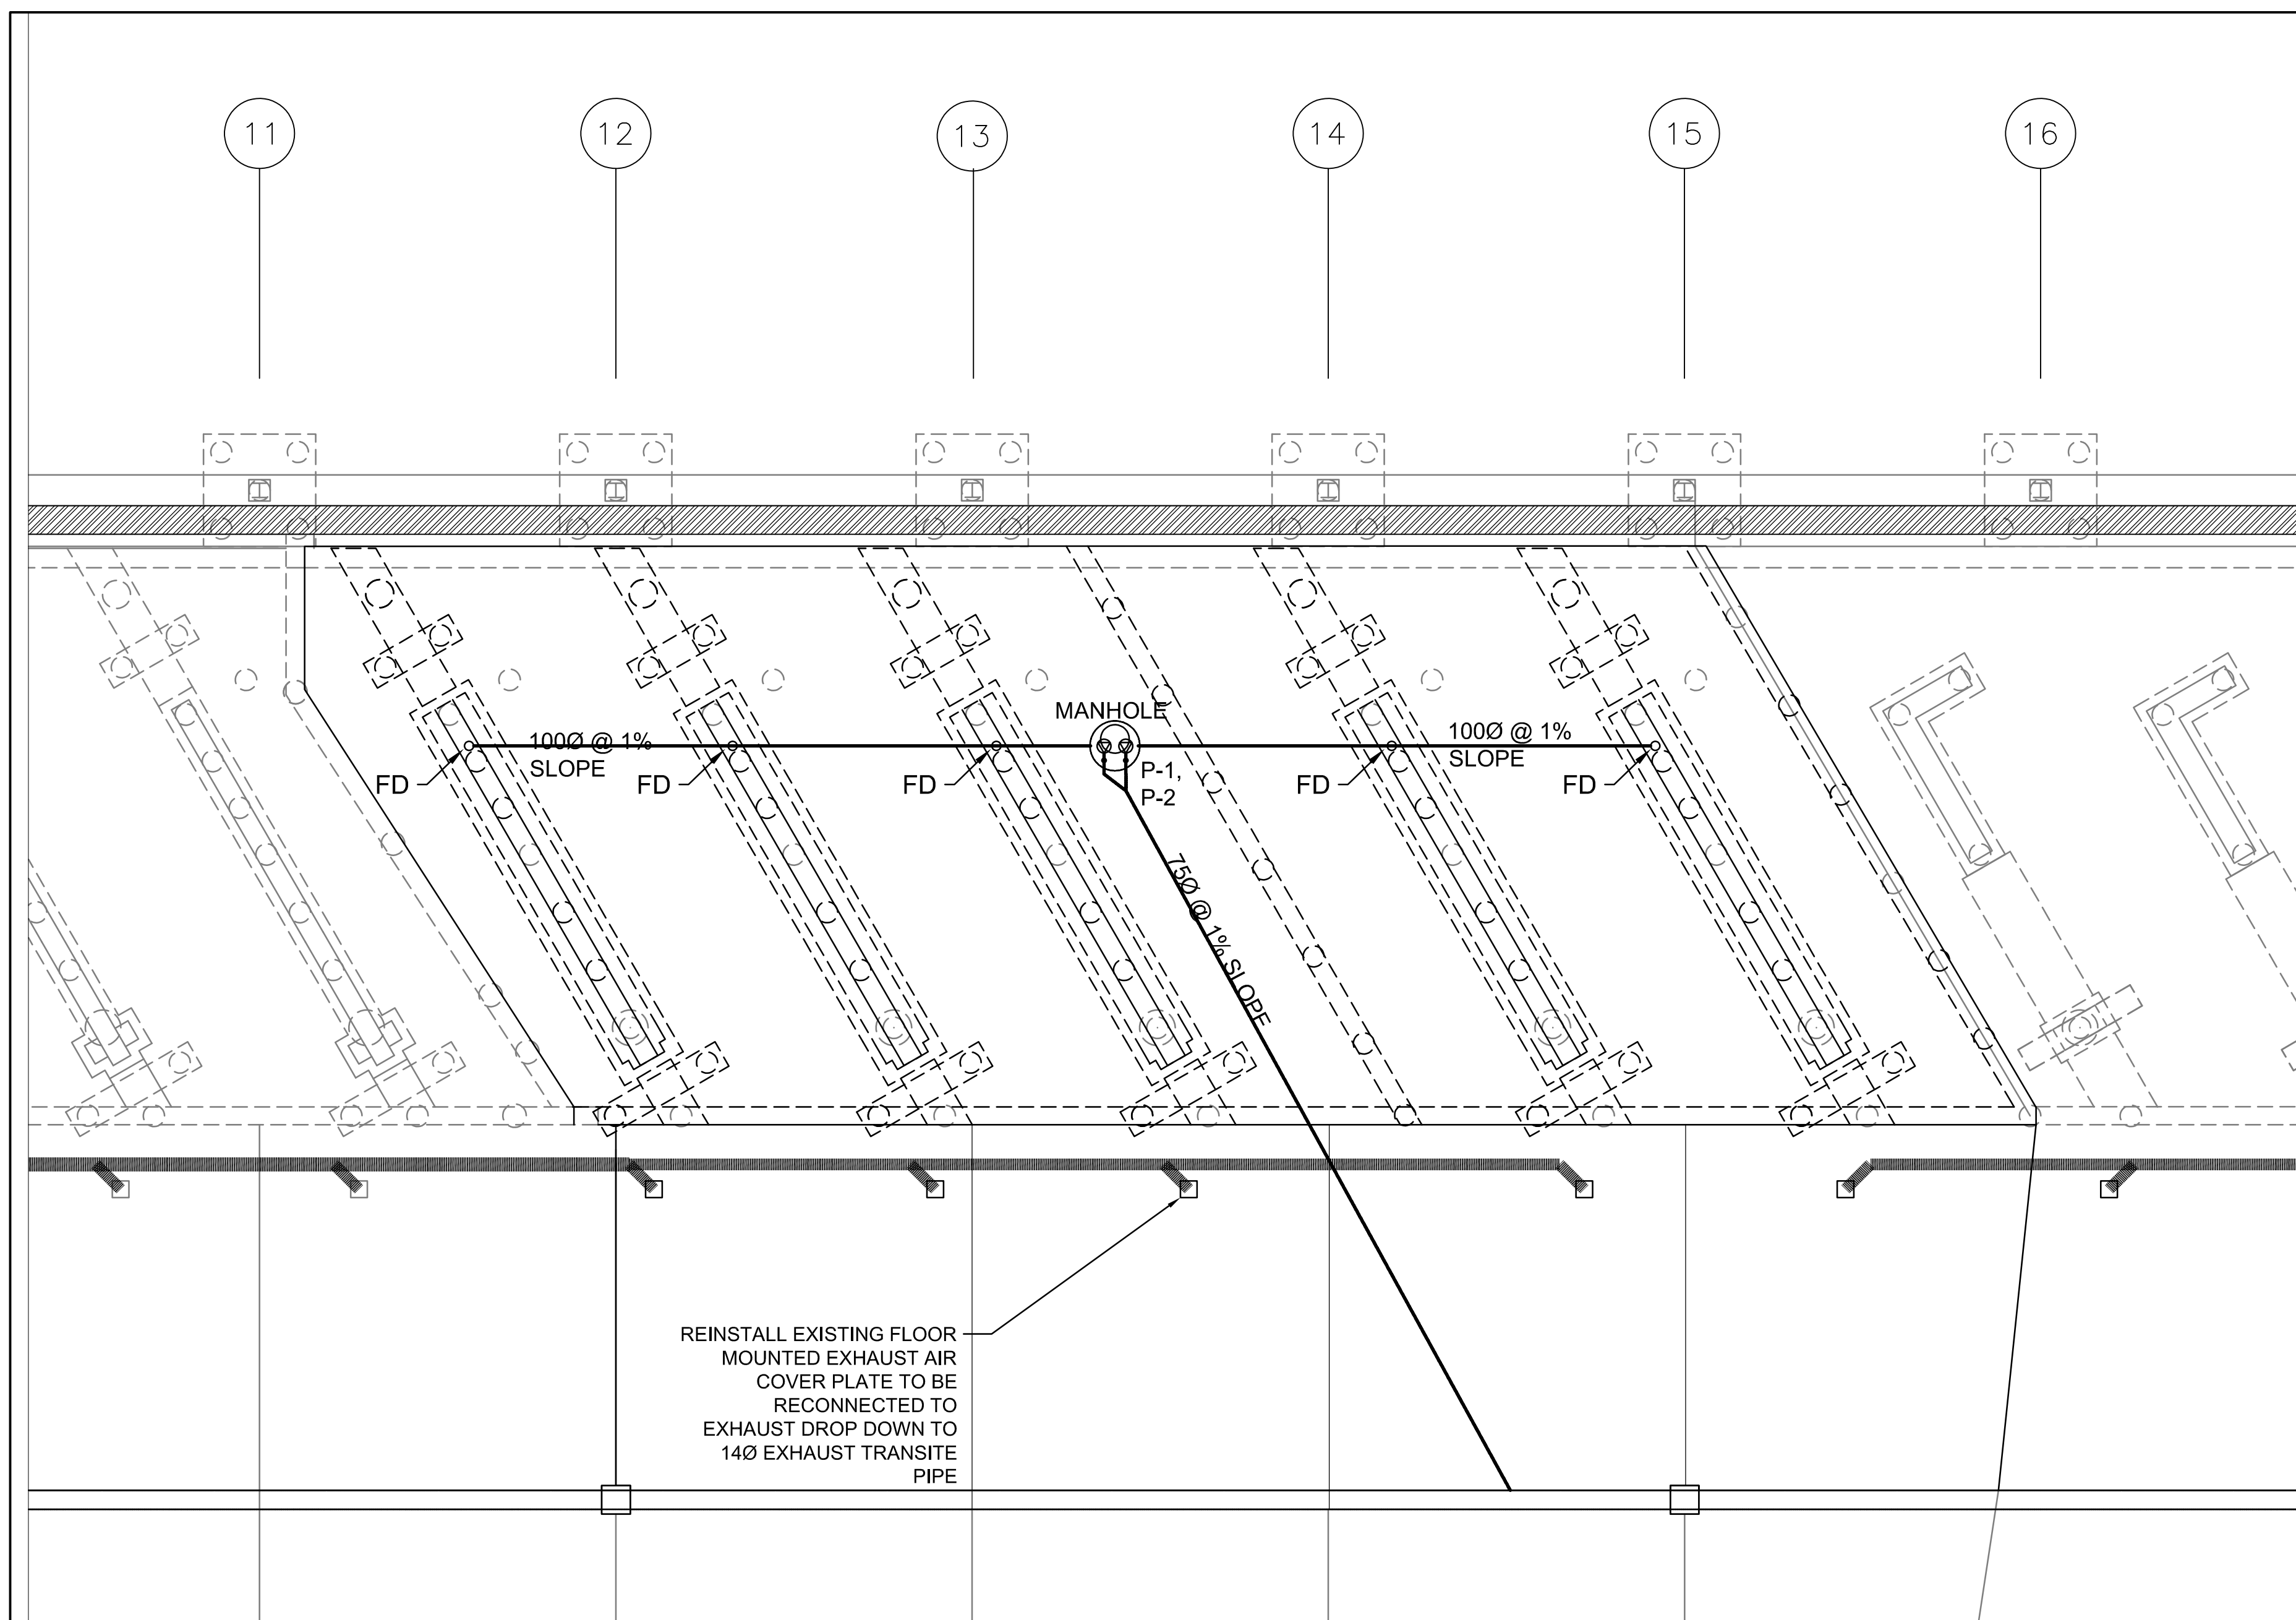



1 MAIN FLOOR PLUMBING PLAN
 M-102 1:100

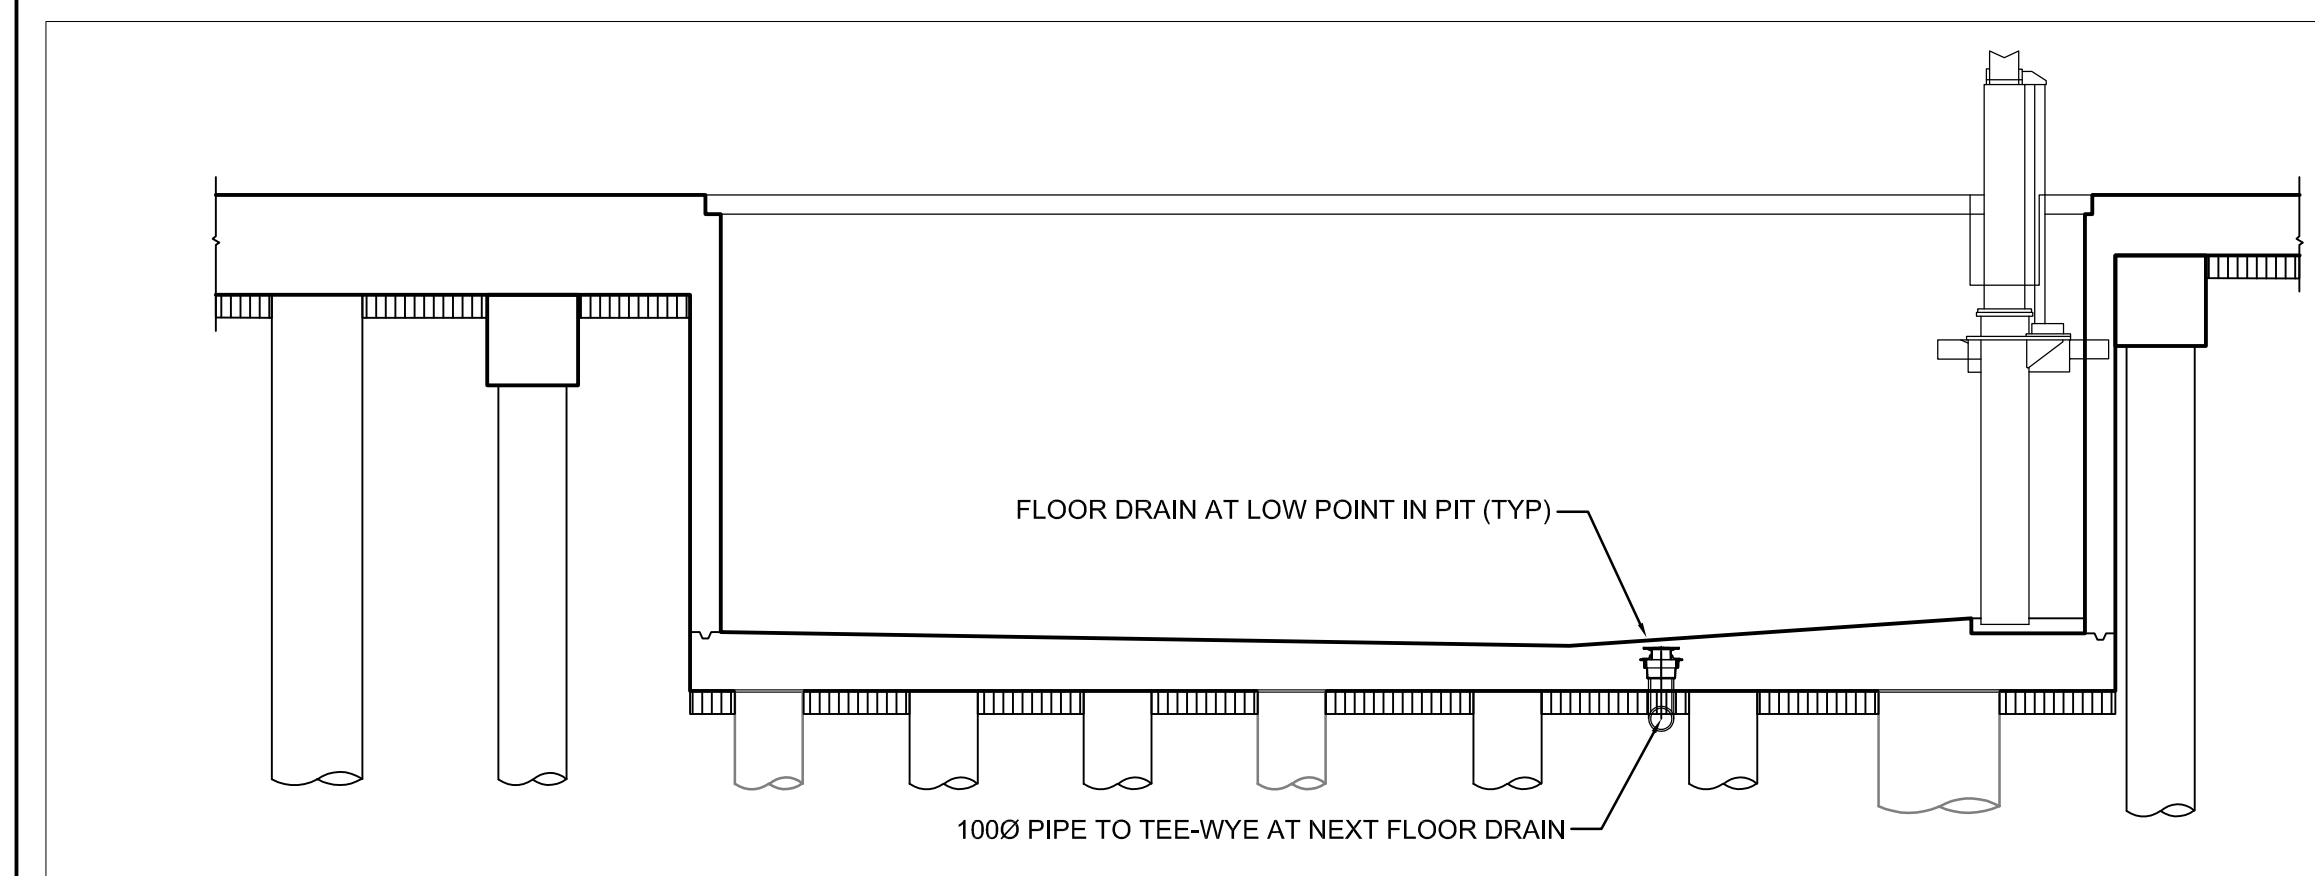

2 FLOOR DRAIN ELEVATION VIEW 1
 M-102 NTS

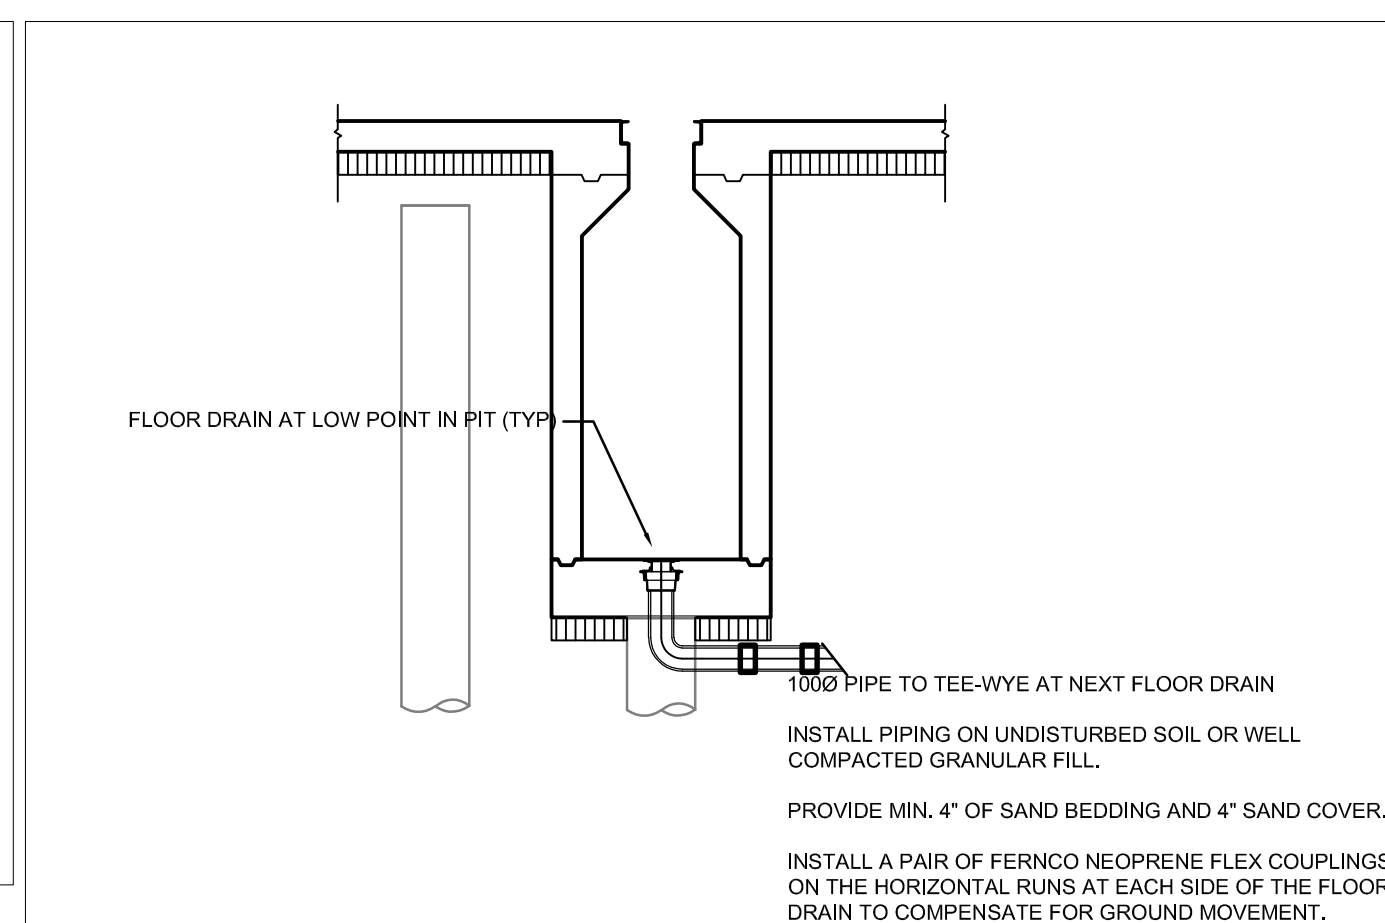

3 FLOOR DRAIN ELEVATION VIEW 2
 M-102 NTS

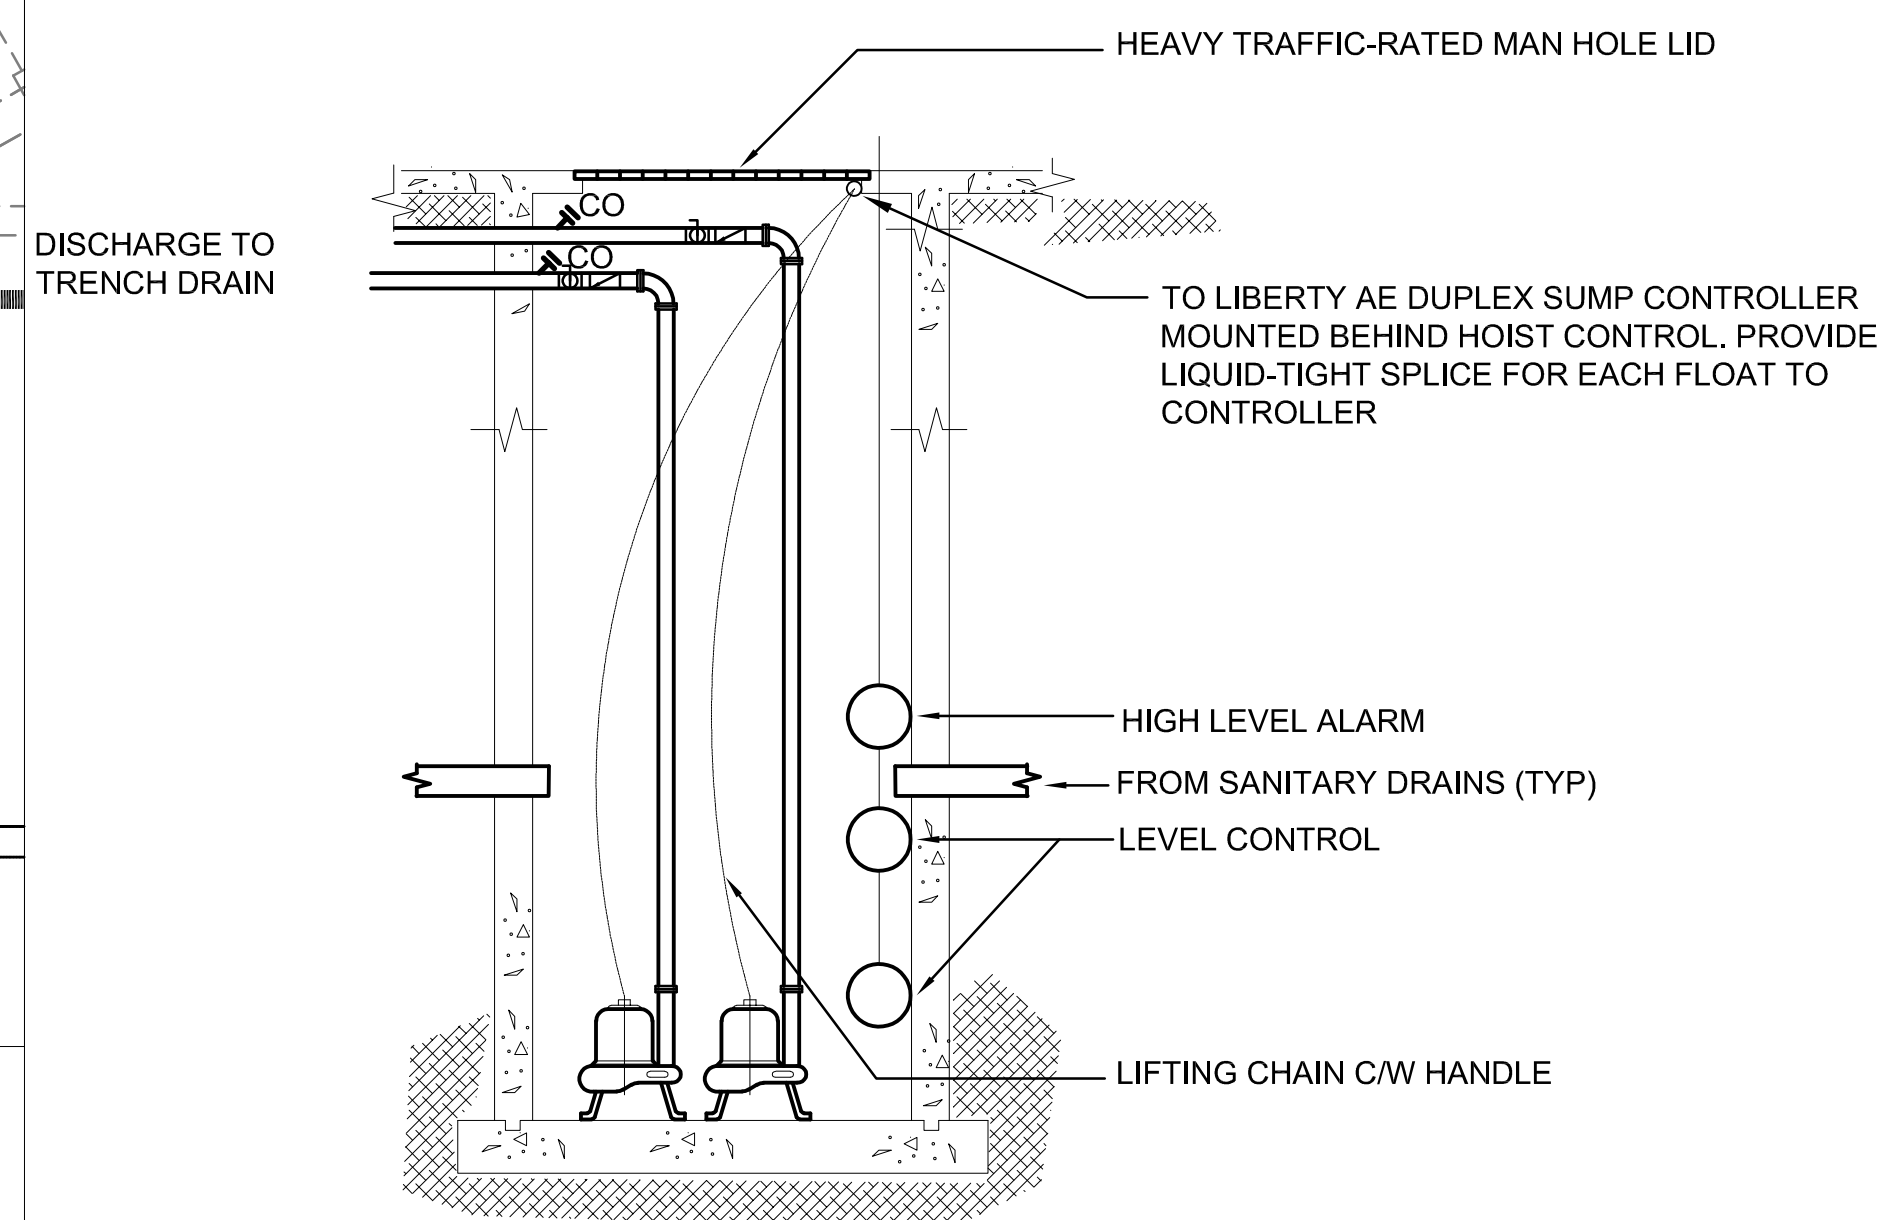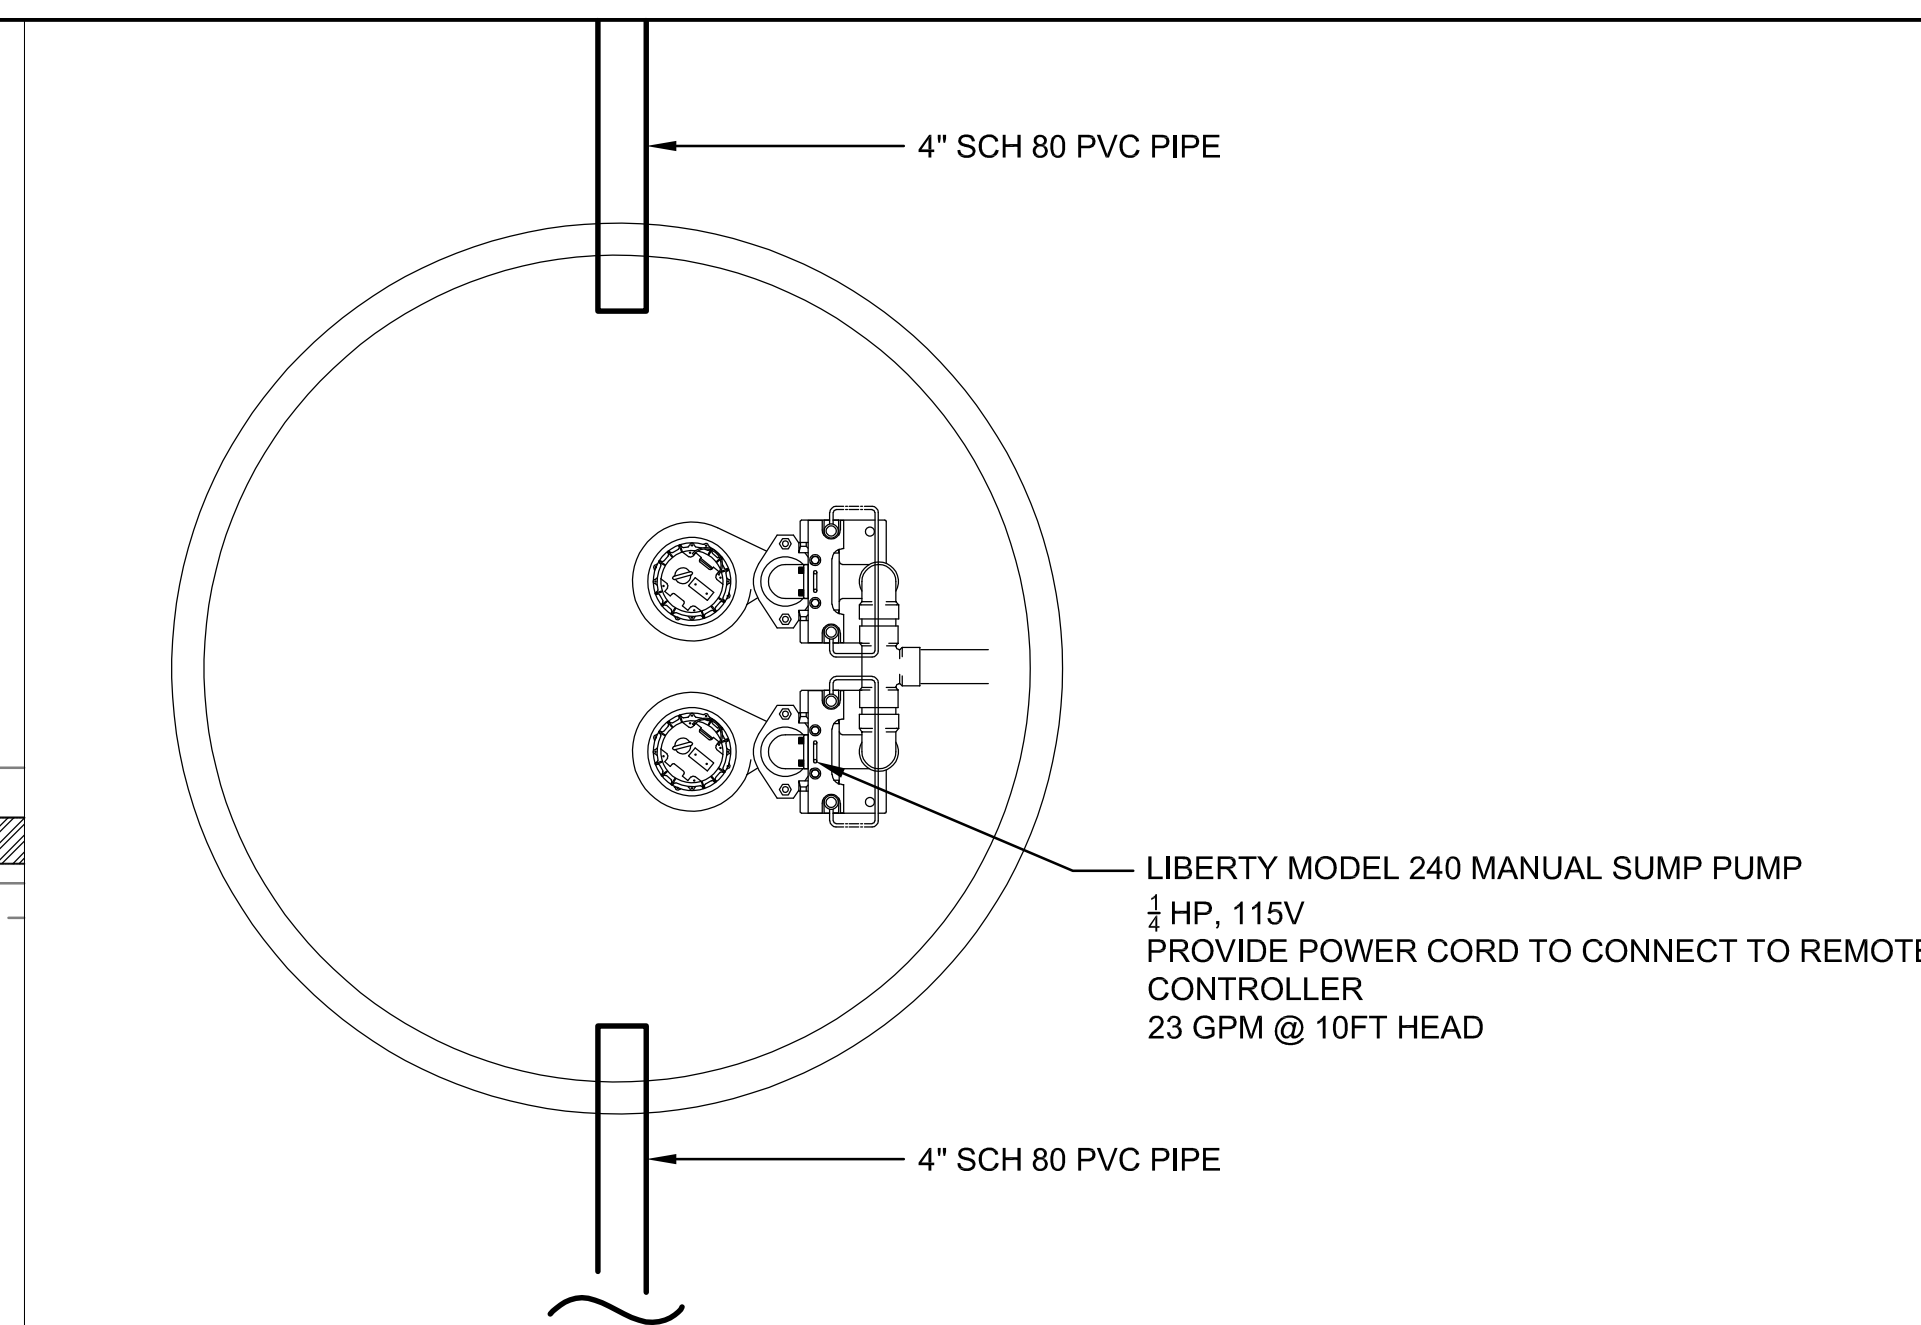

LIBERTY AE24H=3-5 DUPLEX SUMP CONTROLLER

- LOW/HIGH/HIGH LEVEL ALARM
- 120V/208V/240V 1PH 15-20A
- 3 FLOAT SWITCHES
- AUXILIARY ALARM TERMINALS
- NEMA 4X ENCLOSURE
- FLOAT SWITCHES WIRED WITH 18 GA CONDUCTORS, 5A 120/230VAC, HIGH IMPACT PVC
- RED BEACON AND HORN, EXTERIOR TEST/NORMAL/SILENCE SWITCH

4 SUMP PUMP DETAIL
 M-102 NTS