



- NOTES:
1. NO STOCKPILING OF MATERIAL WITHIN 107.0 OF (ASRL). ALL EXCAVATED MATERIAL TO BE REMOVED FROM SITE.
  2. CONTRACTOR TO PROVIDE TEMPORARY SHORING WHERE REQUIRED IN ACCORDANCE WITH SPECIFICATIONS.
  3. CONTRACTOR TO RESTORE SITE, INCLUDING ROADS, CURBS, AND LANDSCAPING, TO PRE-CONSTRUCTION CONDITION.
  4. CONTRACTOR TO PROVIDE AND INSTALL PROPER WARNING SIGNS CONCERNING WORK SITE.

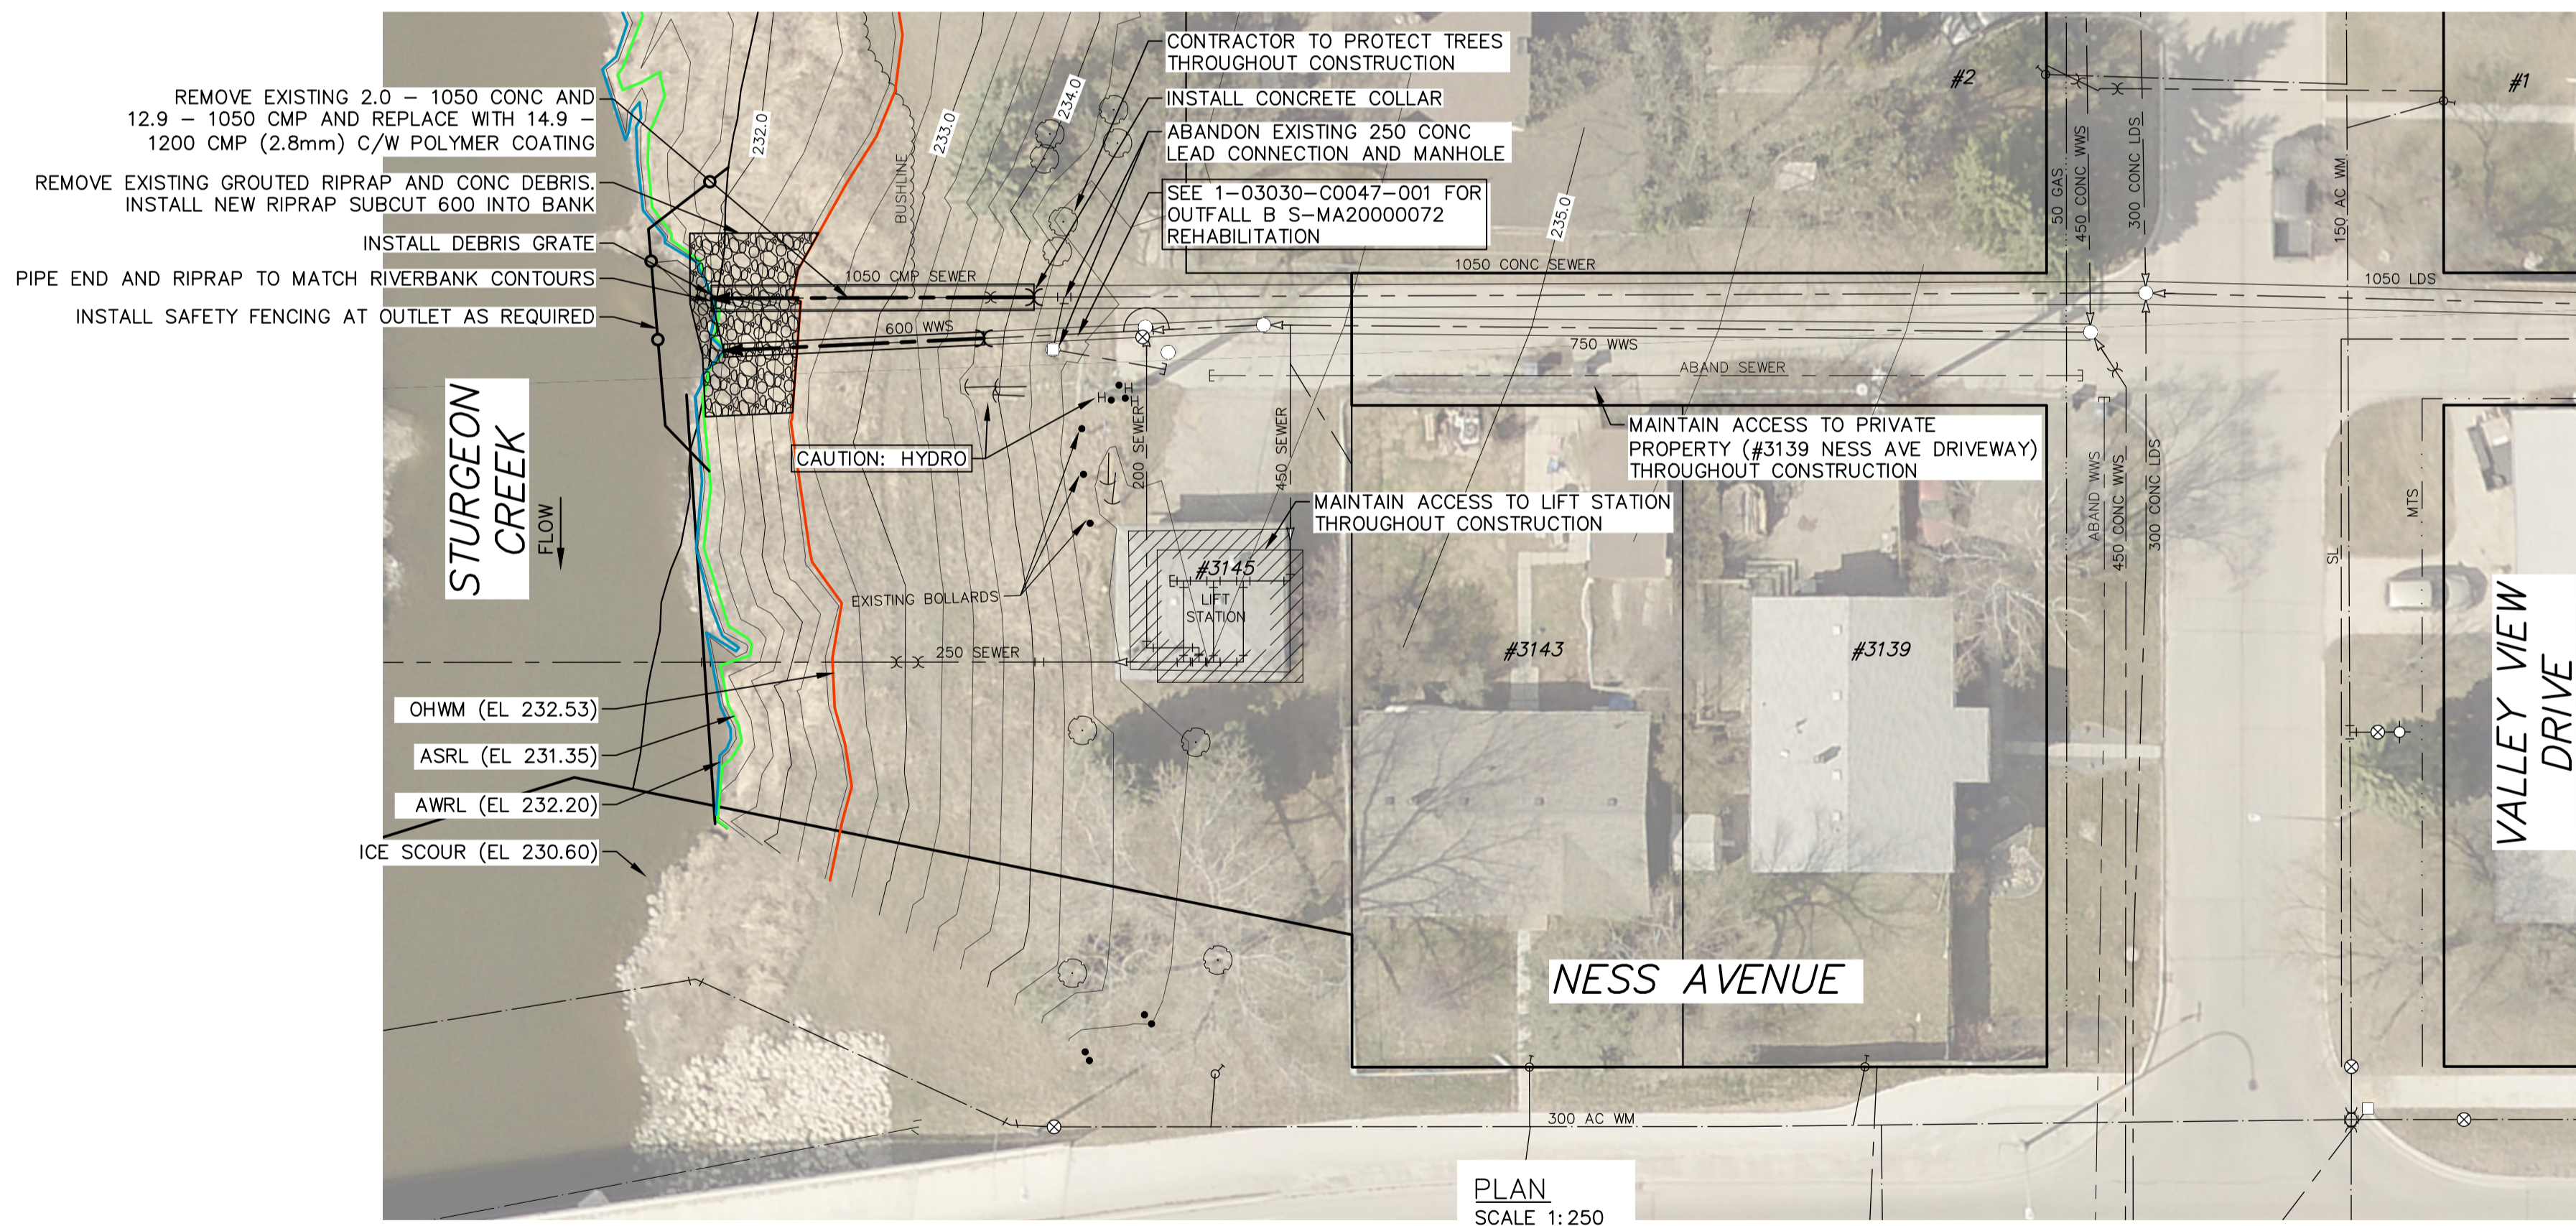

FOR INDEX PAGE SEE DWG 1-03030-D0009-001

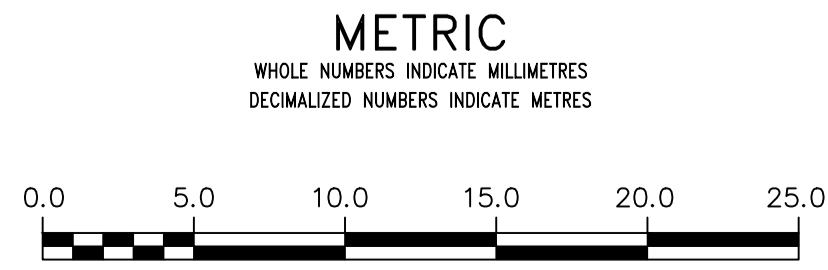

**WARNING**

IF POWER EQUIPMENT OR EXPLOSIVES ARE TO BE USED FOR EXCAVATION ON THIS PROJECT THE CONTRACTOR MUST:

- 1) NOTIFY THE GAS COMPANY OF THE PROPOSED LOCATION OF EXCAVATION.
- 2) TAKE PRECAUTION TO AVOID DAMAGE TO GAS COMPANY INSTALLATIONS.

SEE PROVINCIAL REGULATION 210/72 FOR DETAILS

LOCATION APPROVED UNDERGROUND STRUCTURES

SUPV. U/G STRUCTURES COMMITTEE DATE

NOTE:  
LOCATION OF UNDERGROUND STRUCTURES AS SHOWN ARE BASED ON THE BEST INFORMATION AVAILABLE BUT NO GUARANTEE IS GIVEN THAT ALL EXISTING UTILITIES ARE SHOWN OR THAT THE GIVEN LOCATIONS ARE EXACT. CONFIRMATION OF EXISTENCE AND EXACT LOCATION OF ALL SERVICES MUST BE OBTAINED FROM THE INDIVIDUAL UTILITIES BEFORE PROCEEDING WITH CONSTRUCTION.

B.M. ELEV.	NO.	ISSUED FOR TENDER	DATE	BY
	0	ISSUED FOR TENDER	2021 11 05	
		REVISIONS	DATE	BY

<b>KGS GROUP</b>	
DESIGNED BY	NGV
CHECKED BY	
DRAWN BY	GEL
APPROVED BY	
SCALE:	
HORIZONTAL	1:250
VERTICAL	1:50
DATE	2021 11 04
RELEASED FOR CONSTRUCTION	

ENGINEER'S SEAL

CONSULTANT DRAWING NUMBER  
1-03030-C0046-001

**THE CITY OF WINNIPEG**  
WATER AND WASTE DEPARTMENT  
ENGINEERING DIVISION

2020-2021 OUTFALL PROGRAM  
RENEWAL AND REHABILITATION

**3145 NESS AVENUE OUTFALL A**  
PLAN AND PROFILE  
S-MA2000077

SHEET **9** OF **26**  
CITY DRAWING NUMBER  
1-03030-C0046-001